
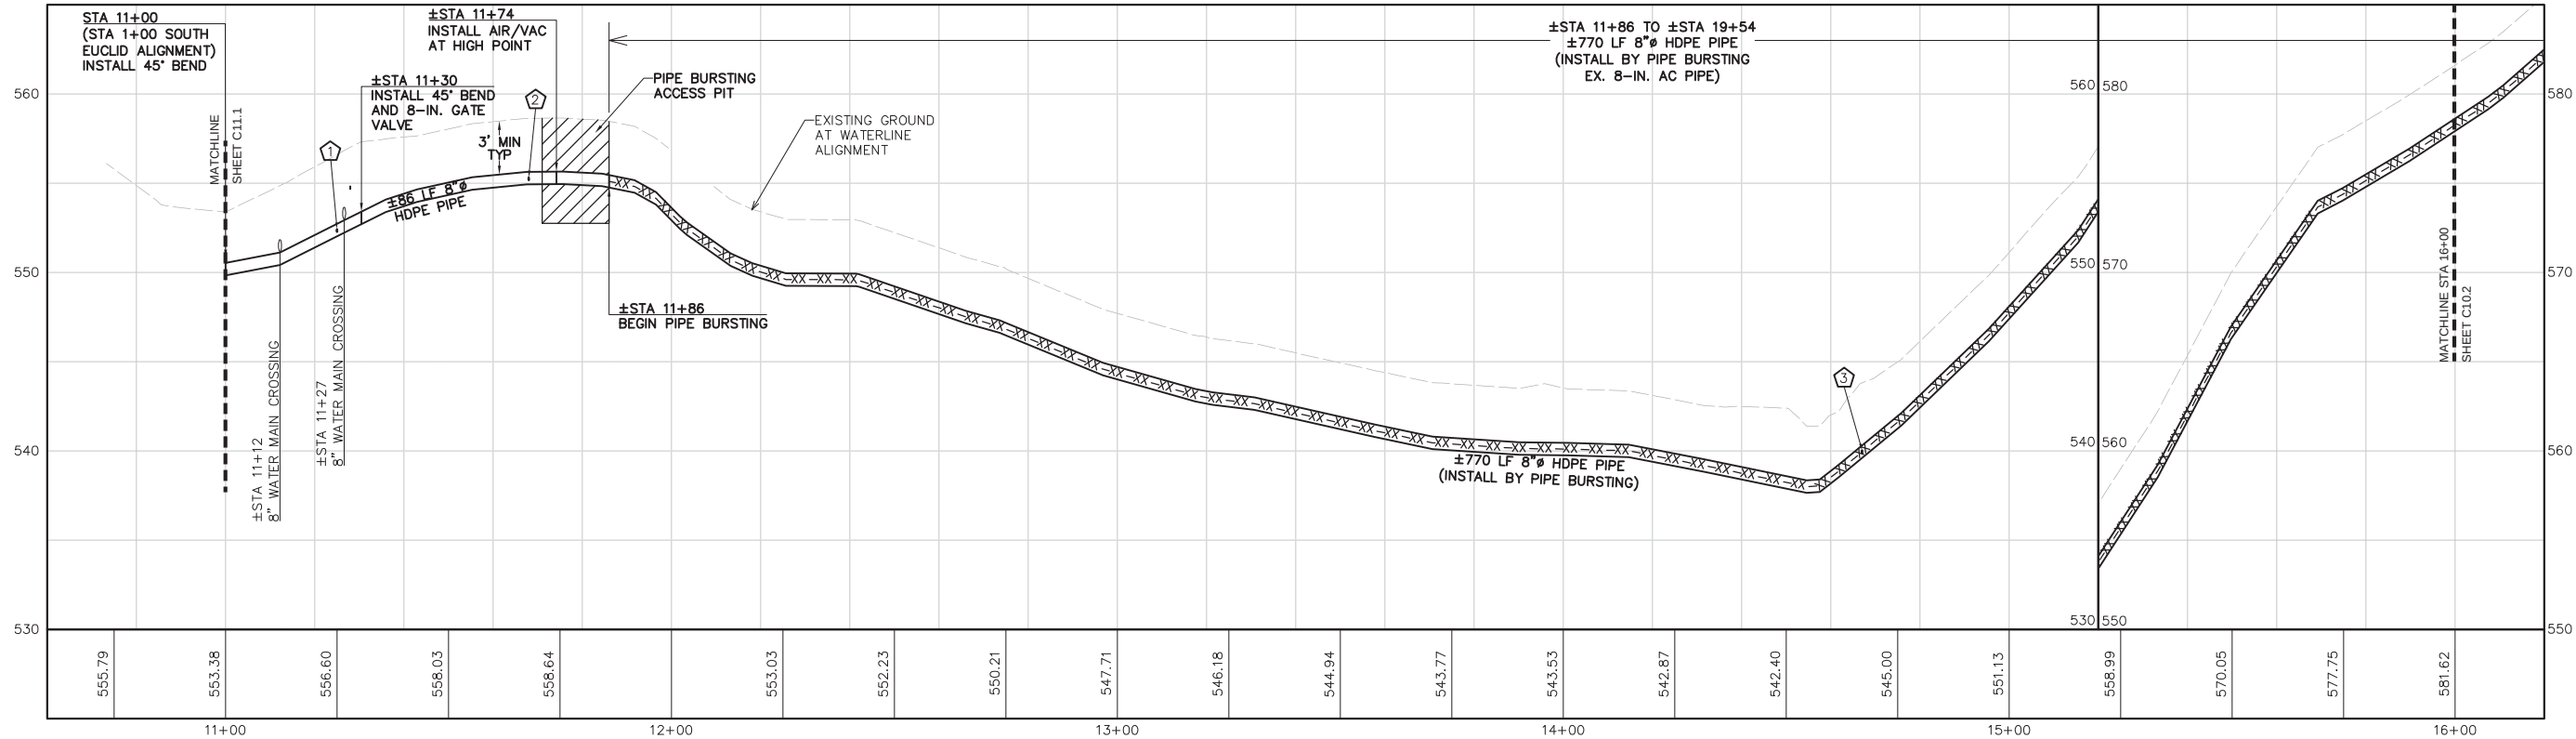


W:\2013\2013-131 LWWSD Geneva AC Mains Replacement\dwg\2013-131 C10.1 C10.2 Plan and Profile 6in Street.dwg, 2/4/2015 11:21:40 AM, PDF-XChange 22x34.pc3, RDN

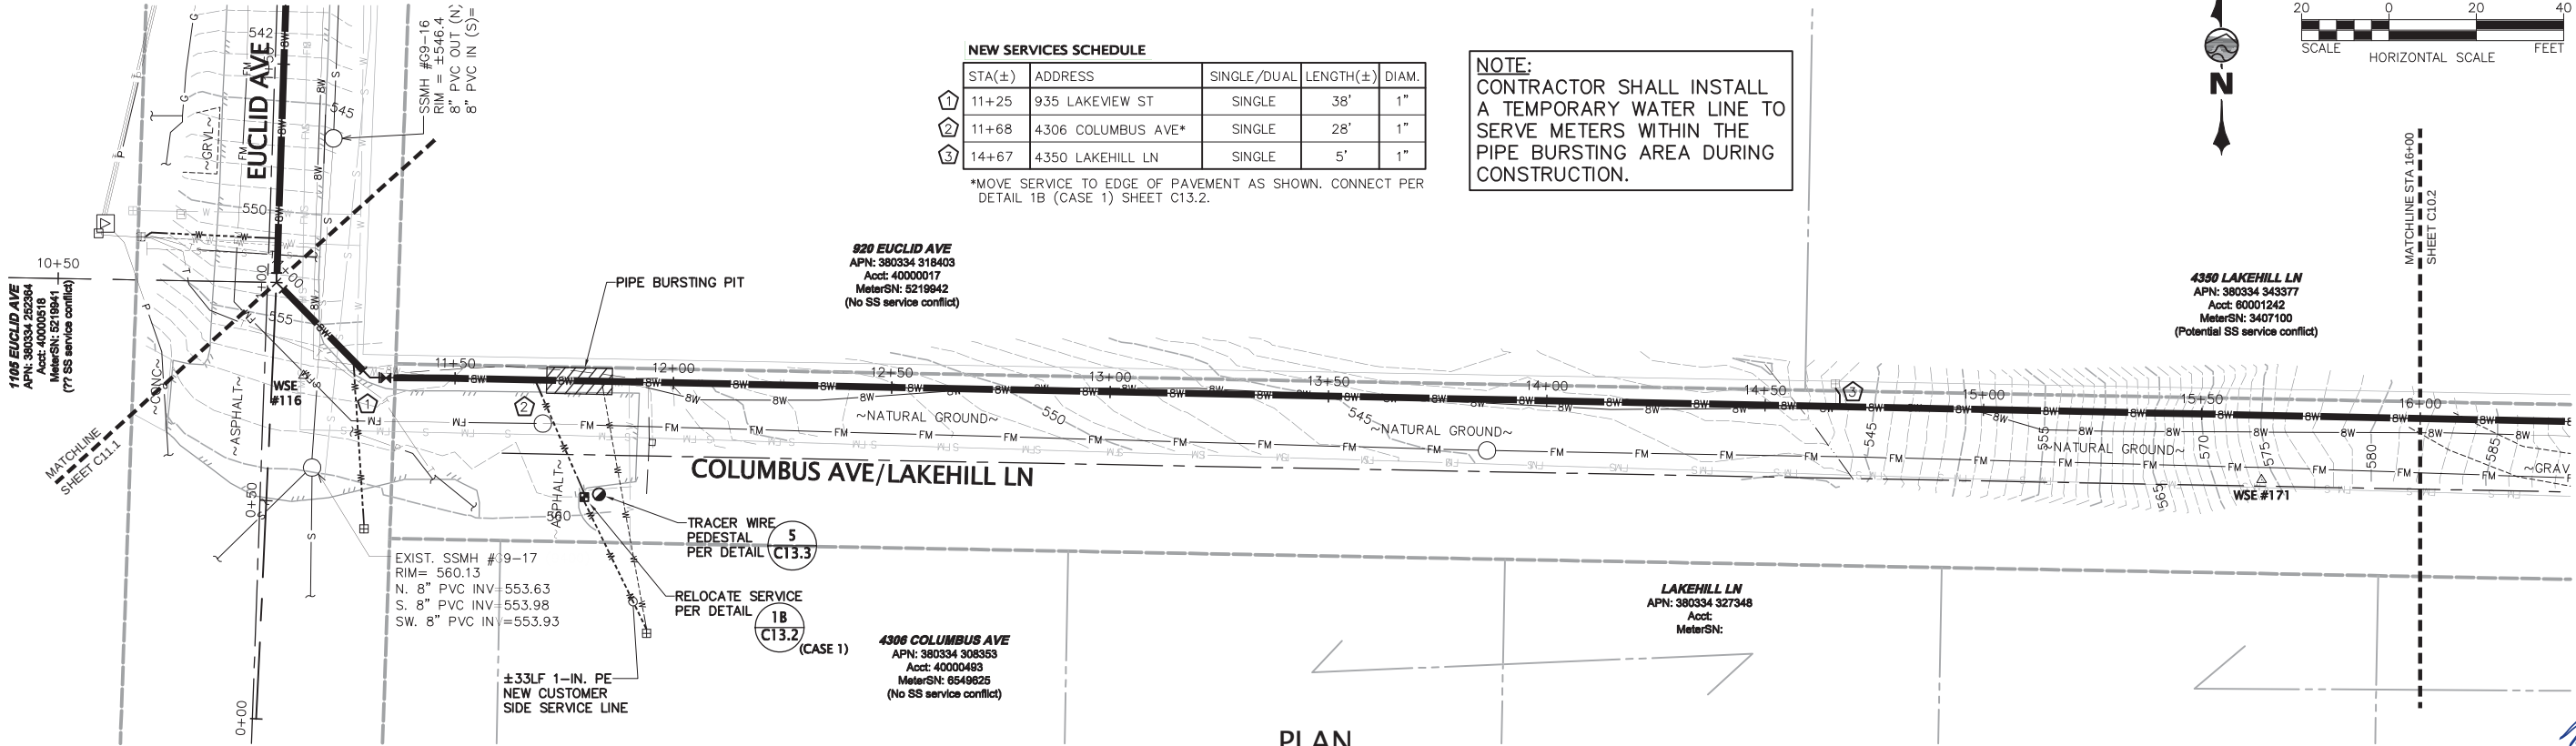


CALL
TWO BUSINESS DAYS
BEFORE YOU DIG
1-800-424-5555
UTILITIES UNDERGROUND LOCATION CENTER

PROFILE – COLUMBUS AVENUE / LAKEHILL LANE

NO.	REVISIONS	BY	DATE

20 0 20 40
SCALE HORIZONTAL SCALE FEET

WILSON ENGINEERING, LLC
805 DUPONT STREET
BELLINGHAM, WA 98225
(360) 733-6100 • FAX (360) 647-9061
www.wilsonengineering.com

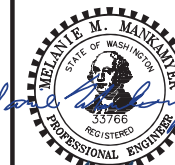

DESIGNED BY MIM
DRAWN BY RDN
CHECKED BY DNC

LAKE WHATCOM WATER & SEWER DISTRICT


WASHINGTON
GENEVA AC MAINS REPLACEMENT PROJECT

PLAN & PROFILE – COLUMBUS AVE./LAKEHILL LANE
STA 11+00 TO STA 16+00

SHEET
C10.1
DATE
FEBRUARY 4, 2015
SCALE
AS SHOWN

OF
37
JOB NUMBER
2013-131

W:\2013\2013-131 LWWSD Geneva AC Mains Replacement\dwg\2013-131 C10.1 C10.2 Plan and Profile 6in Street.dwg, 2/4/2015 11:22:15 AM, PDF-XChange 22x34.pc3, RDN

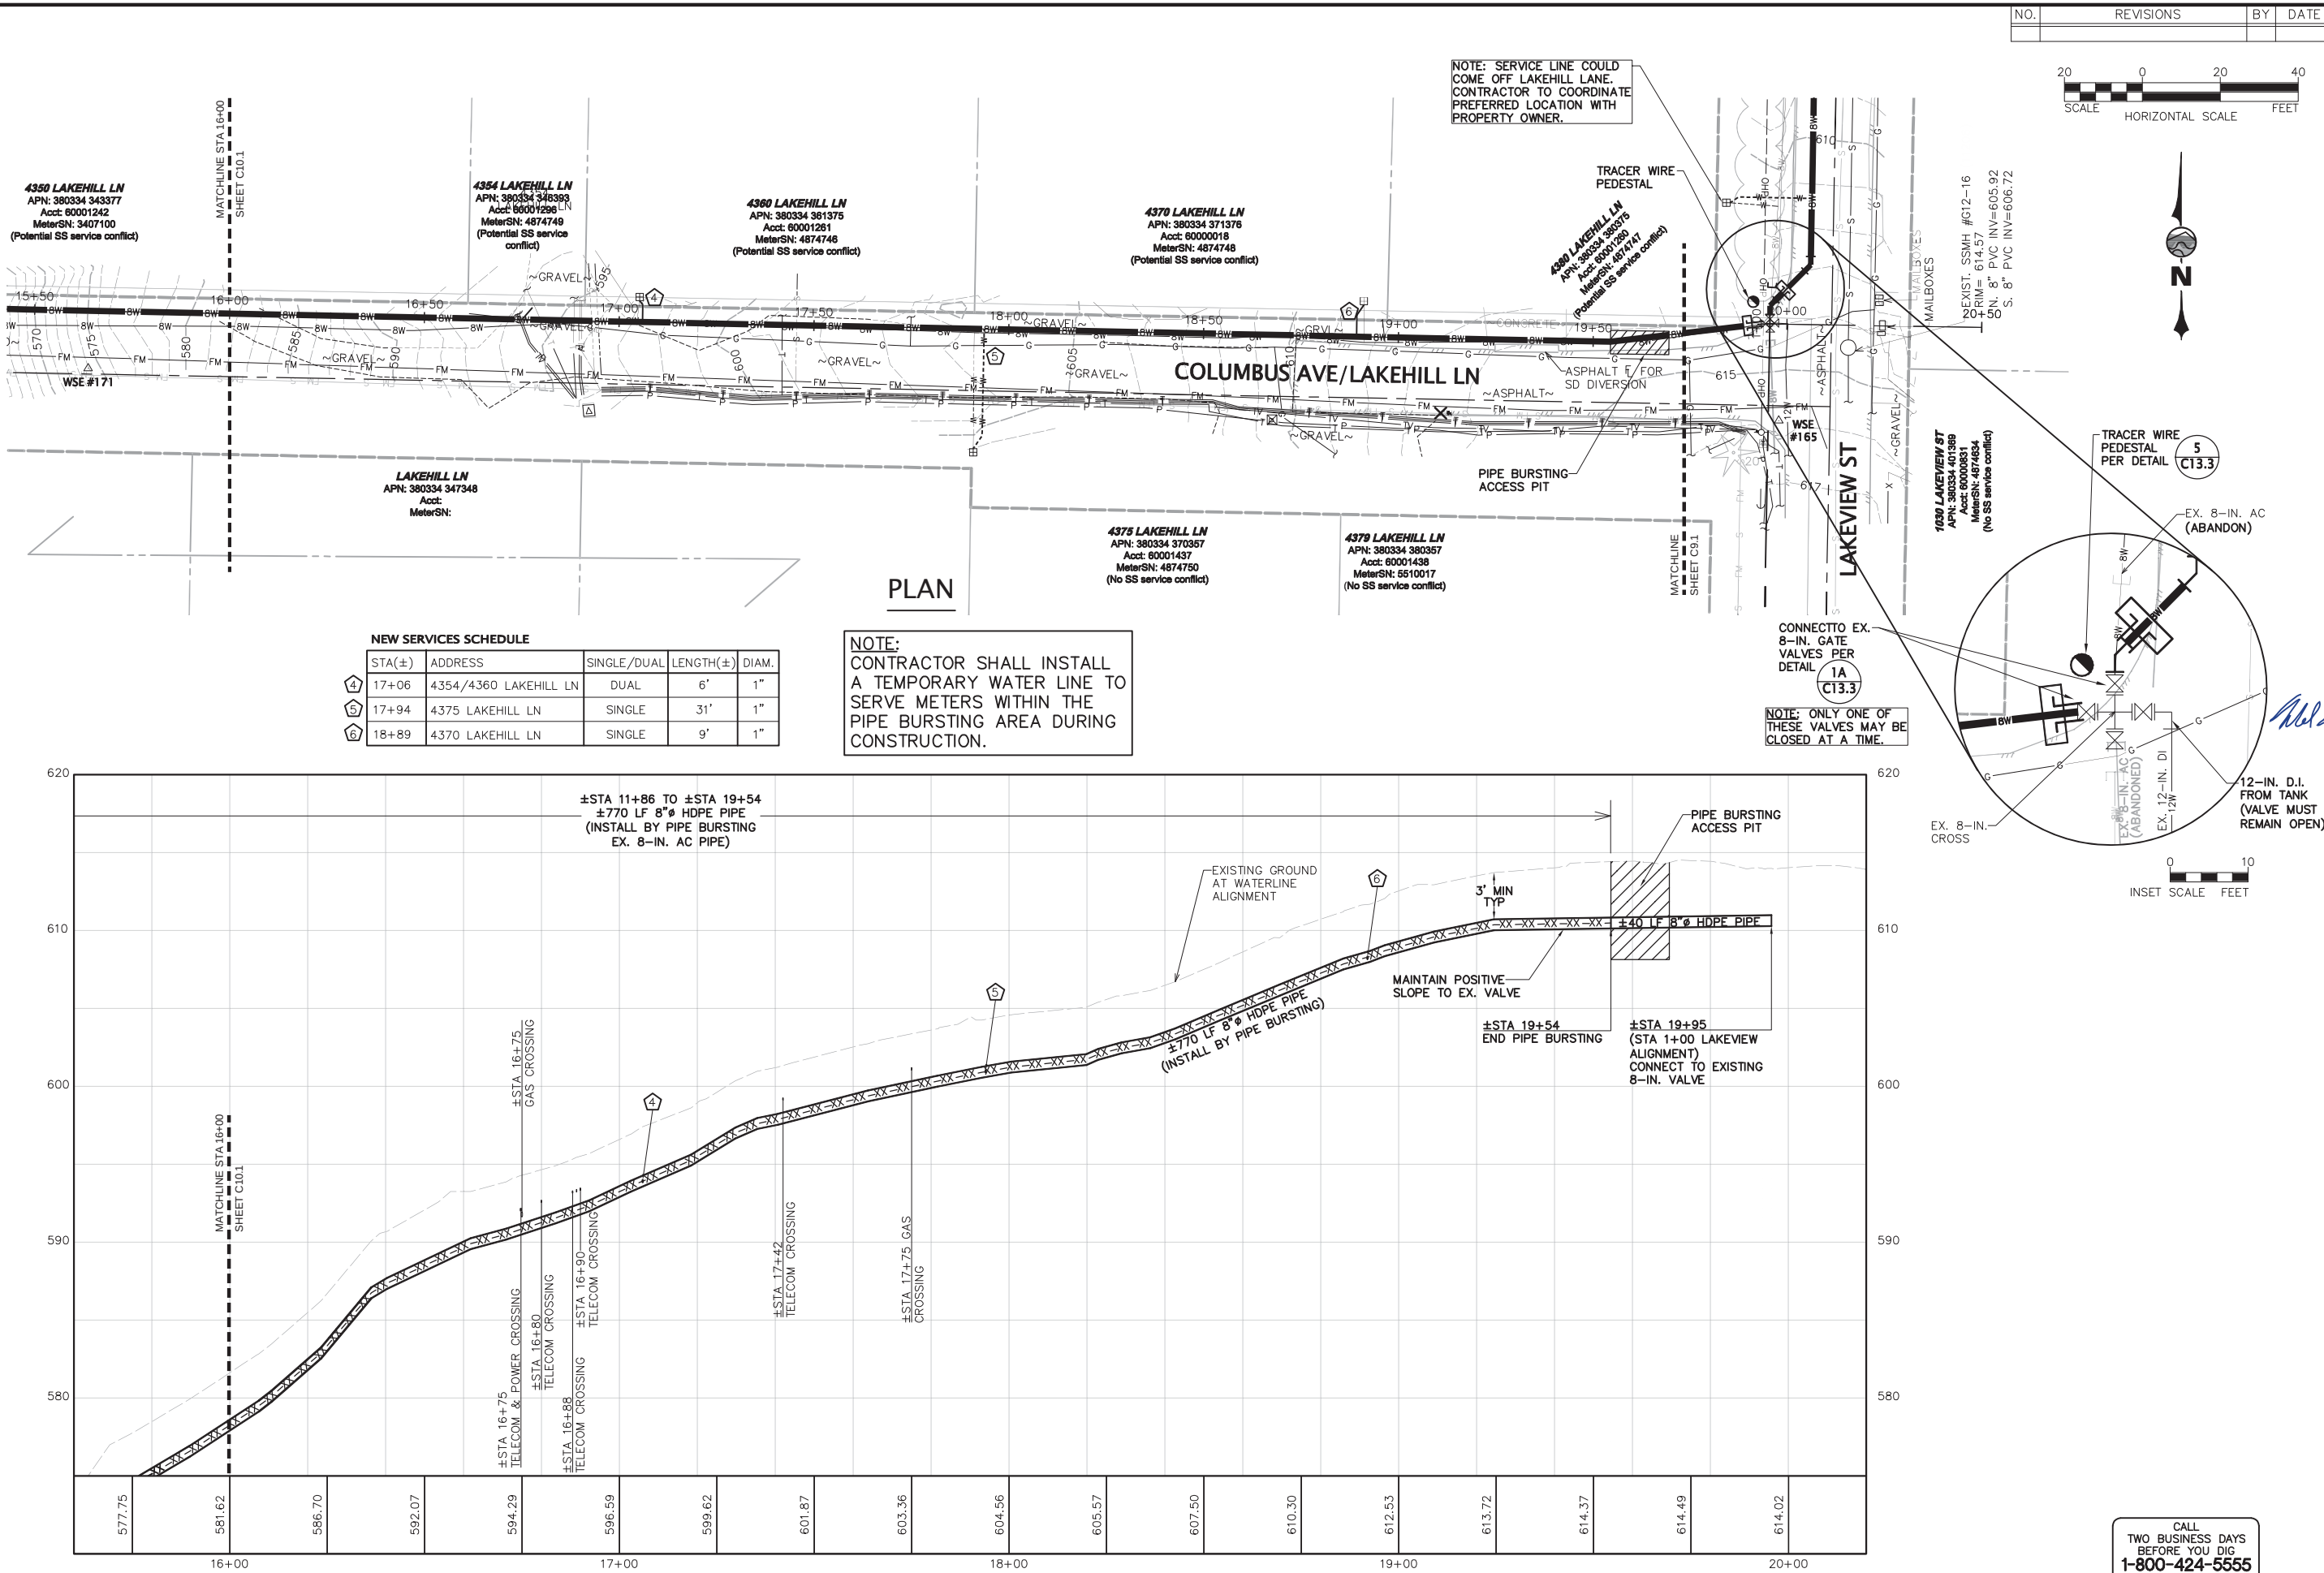

NO.		REVISIONS		BY	DATE

WILSON ENGINEERING, LLC
805 DUPONT STREET
BELLINGHAM, WA 98225
(360) 733-6100 • FAX (360) 647-0061
www.wilsonengineering.com

Wilson
SURVEY/ENGINEERING

STATE OF WASHINGTON
PROFESSIONAL ENGINEER
35766
2/4/15

DESIGNED BY: MIM
DRAWN BY: RDN
CHECKED BY: DNC

LAKE WHATCOM WATER & SEWER DISTRICT
GENEVA AC MAINS REPLACEMENT PROJECT
PLAN & PROFILE - COLUMBUS AVE./LAKEHILL LANE
STA 16+00 TO STA 19+90

SHEET: **C10.2**
DATE: FEBRUARY 4, 2015
SCALE: AS SHOWN
JOB NUMBER: 2013-131

OF: **37**

CALL
TWO BUSINESS DAYS
BEFORE YOU DIG
1-800-424-5555
UTILITIES UNDERGROUND LOCATION CENTER