





W:\2013\2013-131 LWWSD Geneva AC Mains Replacement\dwg\2013-131 C12.1 C12.4 Plan and Profile RidgeWood.dwg, 2/4/2015 11:24:42 AM, PDF-XChange 22x34.pc3, RDW

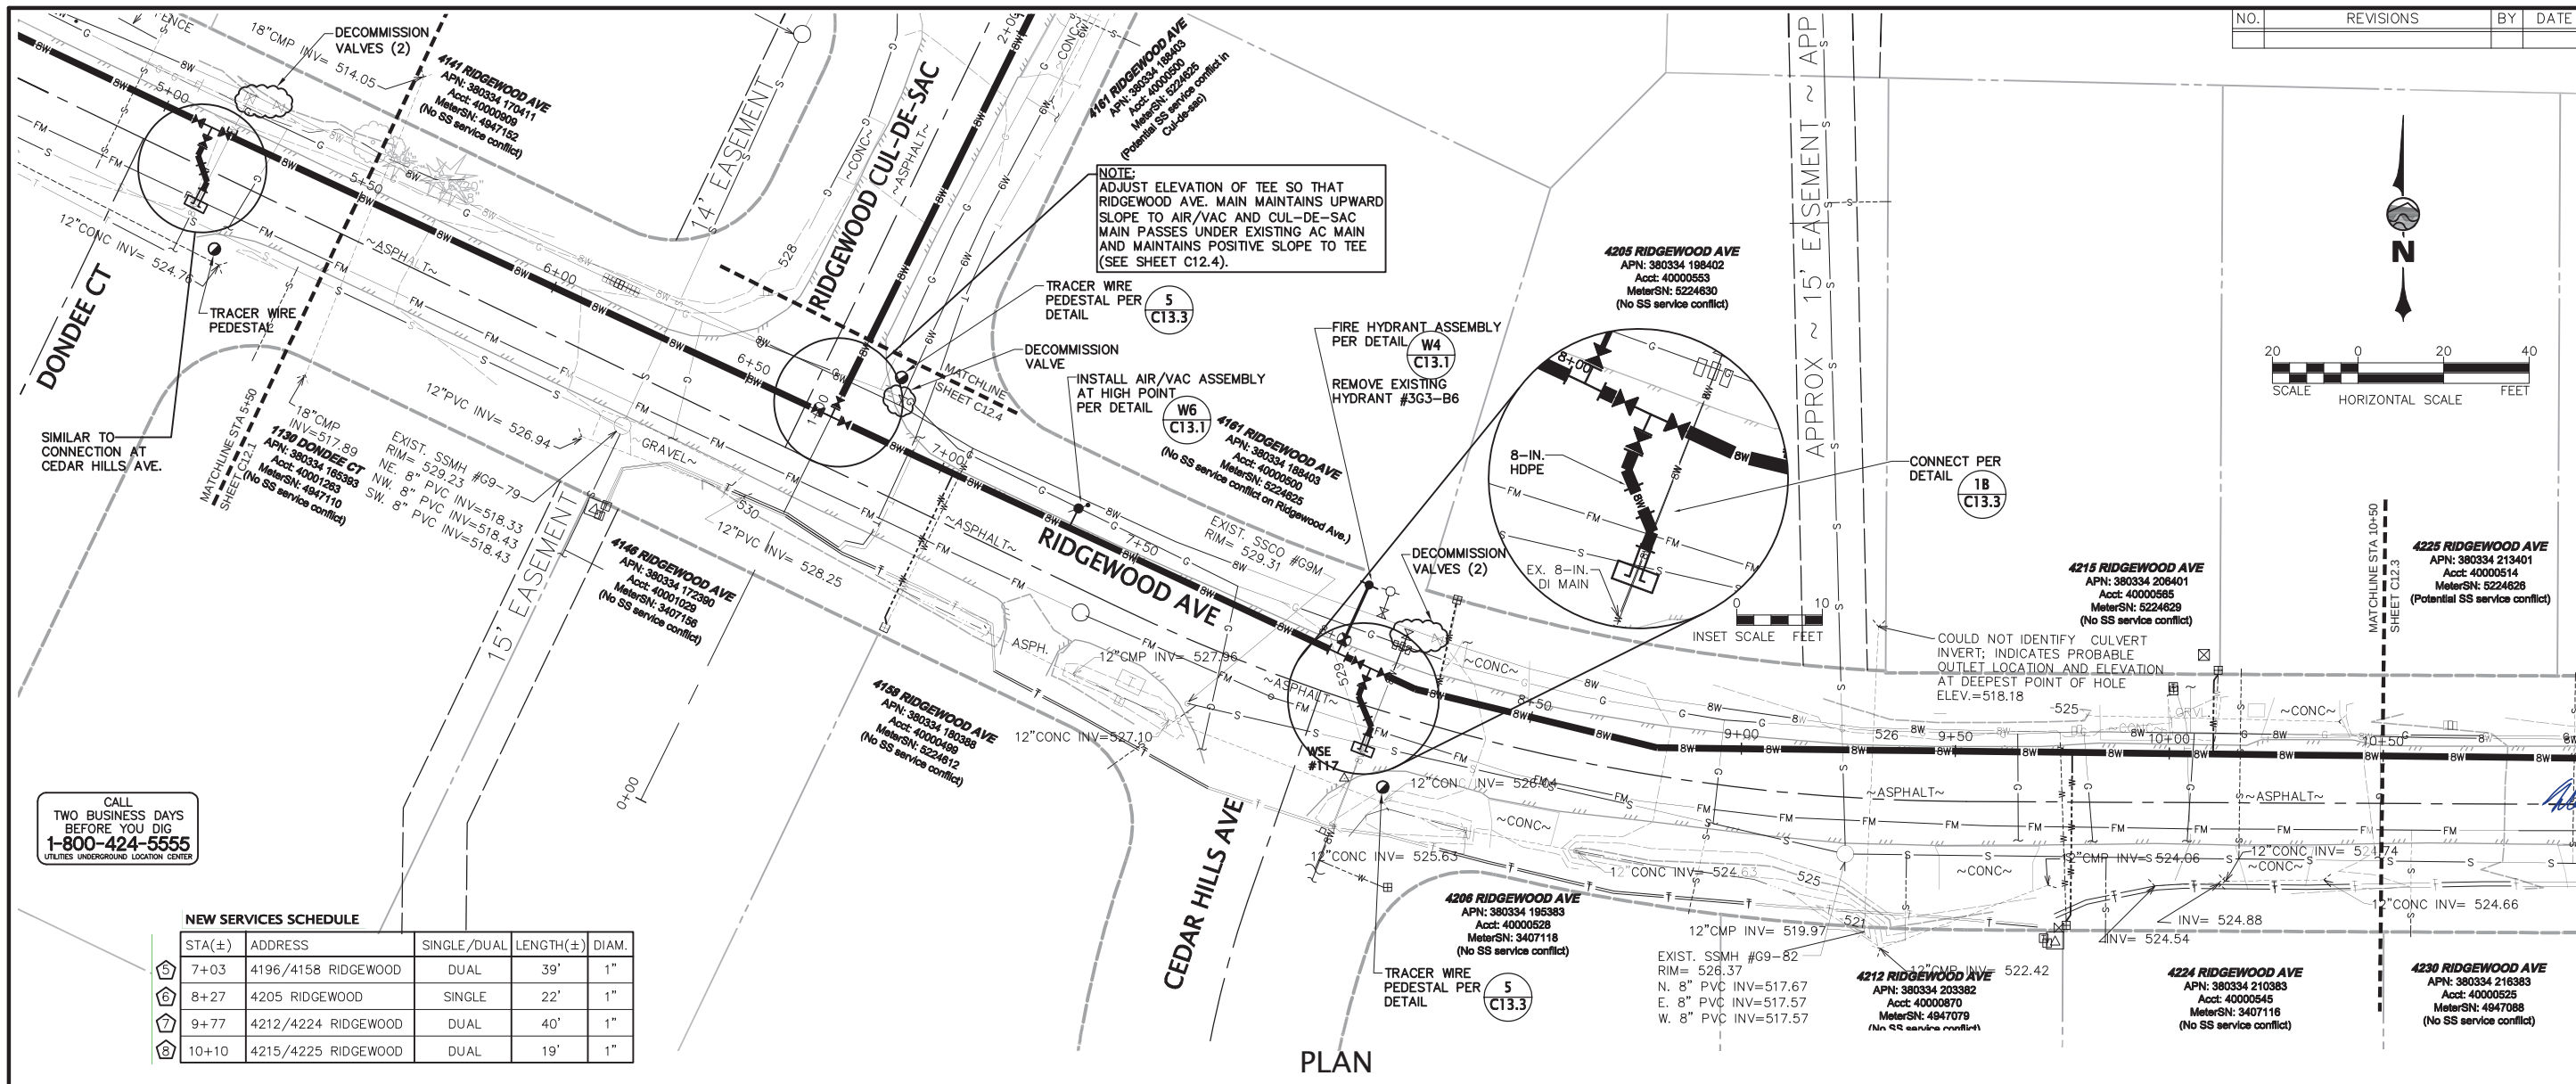

CALL
TWO BUSINESS DAYS
BEFORE YOU DIG
1-800-424-5555
UTILITIES UNDERGROUND LOCATION CENTER


NEW SERVICES SCHEDULE				
STA(±)	ADDRESS	SINGLE/DUAL	LENGTH(±)	DIAM.
7+03	4196/4158 RIDGEWOOD	DUAL	39'	1"
8+27	4205 RIDGEWOOD	SINGLE	22'	1"
9+77	4212/4224 RIDGEWOOD	DUAL	40'	1"
10+10	4215/4225 RIDGEWOOD	DUAL	19'	1"

PLAN

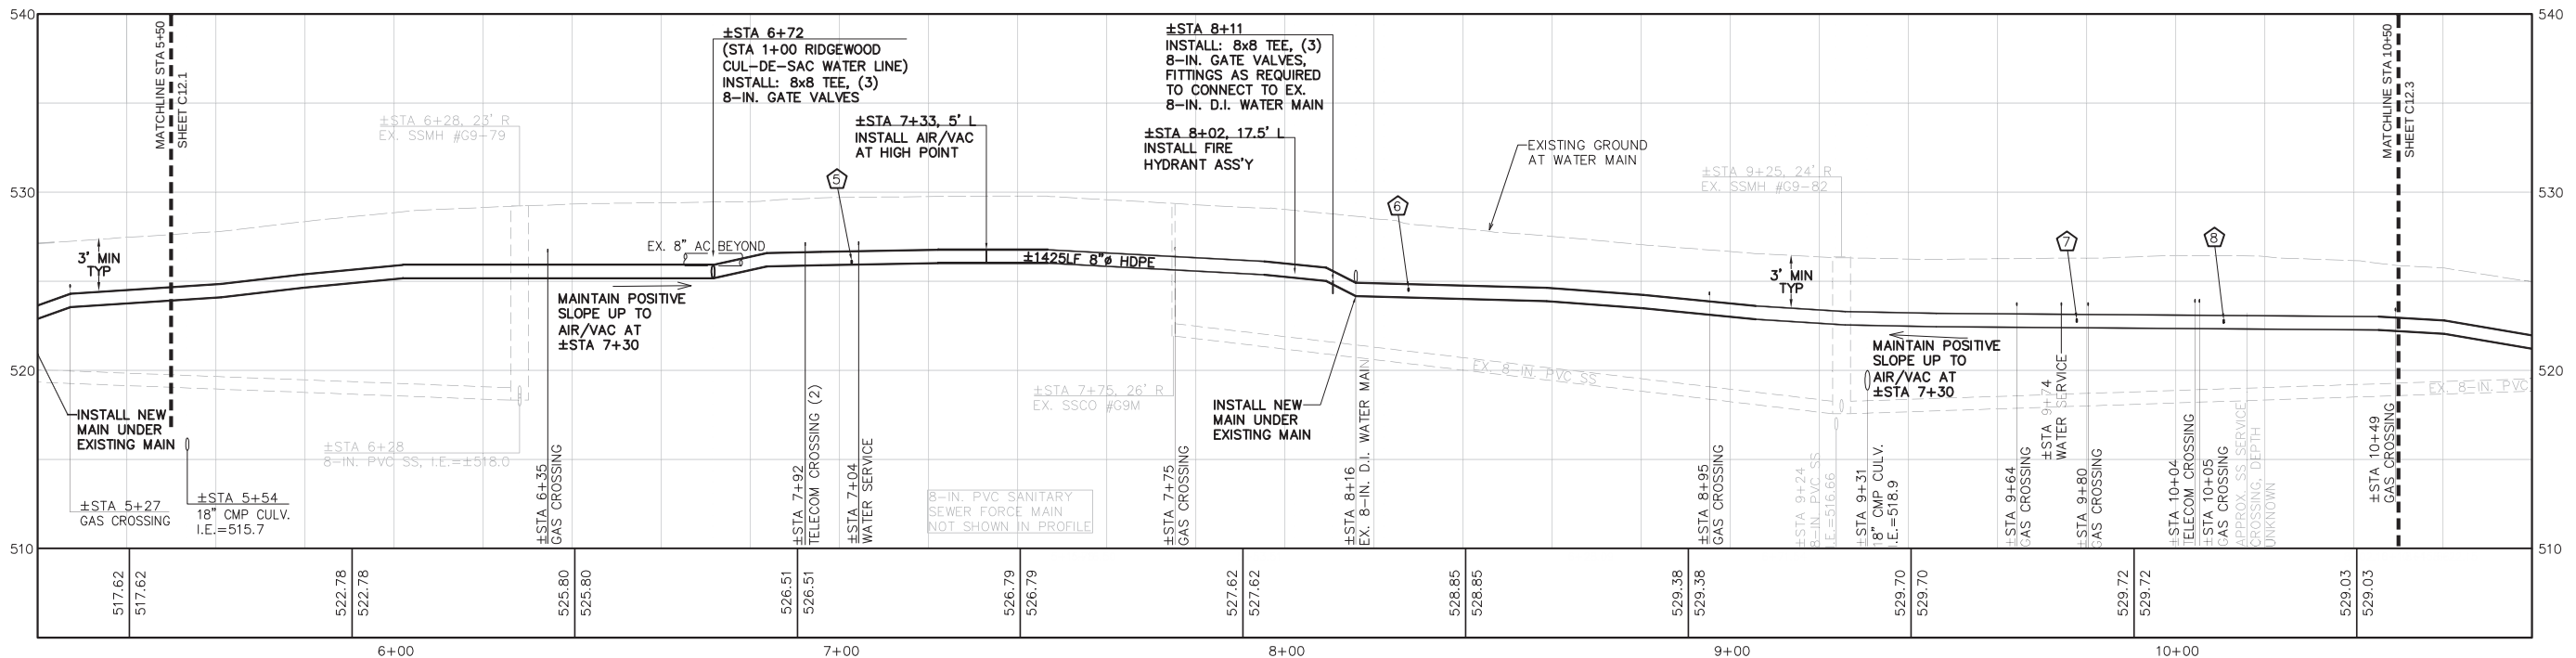

PROFILE

NO.	REVISIONS	BY	DATE

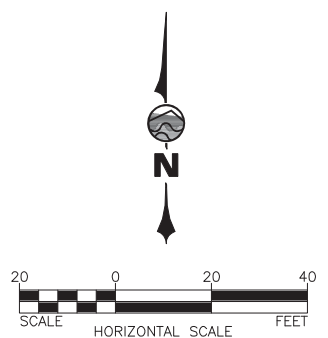

WILSON ENGINEERING, LLC
805 DUPONT STREET
BELLINGHAM, WA 98225
(360) 733-6100 • FAX (360) 647-0061
www.wilsonengineering.com

Wilson
SURVEY/ENGINEERING

DESIGNED BY
MMH

DRAWN BY
RDW

CHECKED BY
DNC

STATE OF WASHINGTON
PROFESSIONAL ENGINEER
35766
2/4/15

LAKE WHATCOM WATER & SEWER DISTRICT

WASHINGTON

GENEVA AC MAINS REPLACEMENT PROJECT

PLAN & PROFILE - RIDGEWOOD AVENUE

STA 5+50 TO STA 10+50

C12.2

DATE
FEBRUARY 4, 2015

SCALE
AS SHOWN

SHEET
OF
37

NO.	REVISIONS	BY	DATE

20 0 20 40

SCALE HORIZONTAL SCALE FEET

The logo for Wilson Survey/Engineering. It features a square icon on the left containing a stylized landscape with a wavy line representing a river or path. To the right of the icon, the word "Wilson" is written in a large, bold, sans-serif font. Below "Wilson", the words "SURVEY/ENGINEERING" are written in a smaller, all-caps, sans-serif font.

LAKE WHATCOM WATER & SEWER DISTRICT

BELLINGHAM

CENEVA AC MAINS REPIACEMENT PROJECT

WASHINGTON

PLAN & PROFILE - RIDGEWOOD AVENUE

STA 10+50 TO STA 15+25

DATE
FEBRUARY 4, 2015SCALE
AS SHOWN

JOB NUMBER

SHEET

C12.3



37



NEW SERVICES SCHEDULE				
STA(±)	ADDRESS	SINGLE/DUAL	LENGTH(±)	DIAM.
11+25	4230/4238 RIDGEWOOD	DUAL	38'	1"
11+69	4233 RIDGEWOOD	SINGLE	17'	1"
13+17	4248/4256 RIDGEWOOD	DUAL	39'	1"
13+31	4248/4259 RIDGEWOOD	DUAL	18'	1"
14+18	4265 RIDGEWOOD	SINGLE	19'	1"

±STA 15+24
(±STA 3+69 EUCLID AVE.
WATER LINE)
INSTALL: 8x8 TEE, (3)
8-IN. GATE VALVES

W:\2013\2013-131 LWWSD Geneva AC Mains Replacement\dwg\2013-131 C12.1 C12.4 Plan and Profile Ridgewood.dwg, 2/4/2015 11:25:40 AM, PDF-XChange 22x34.pc3, RDW

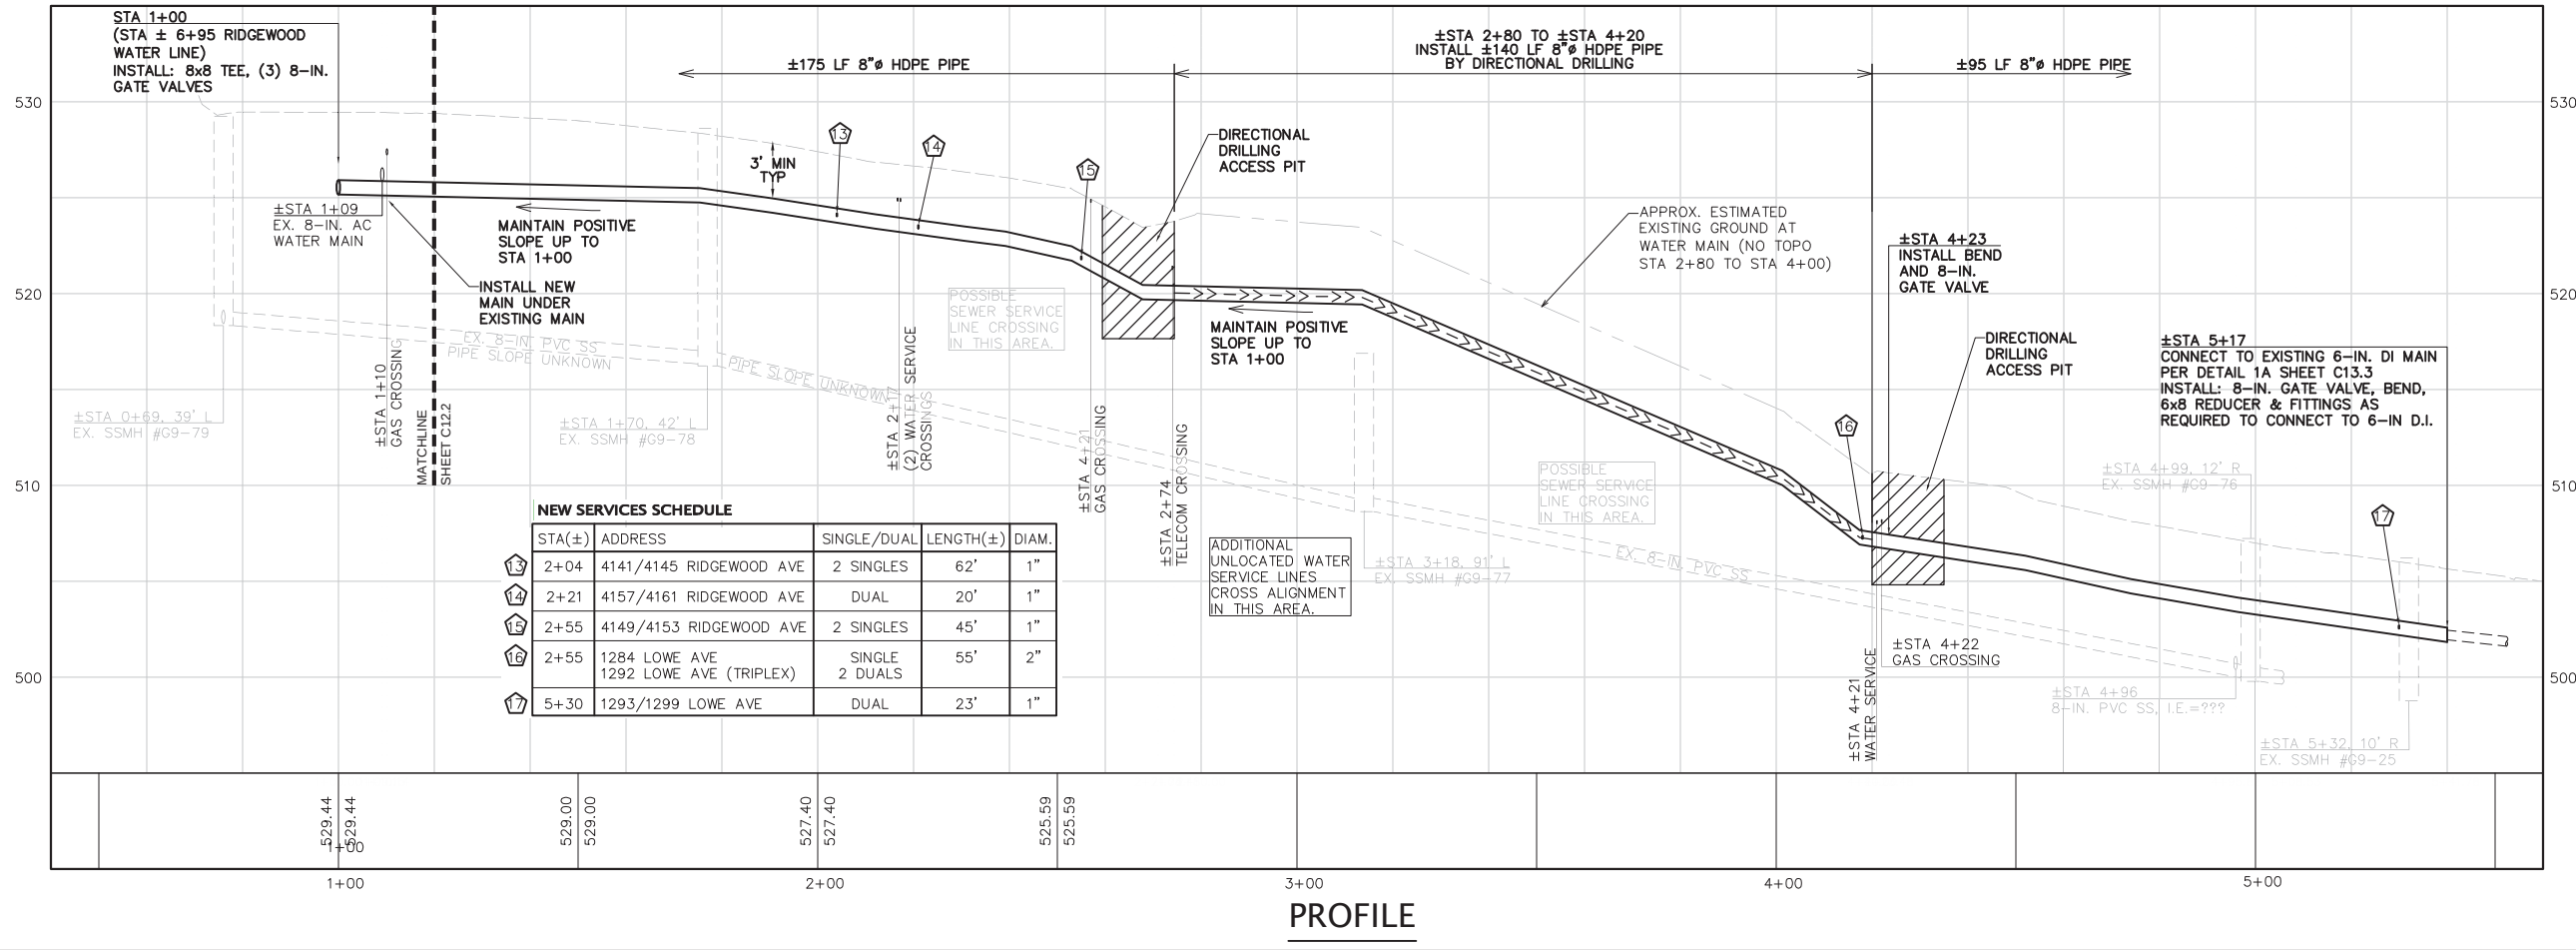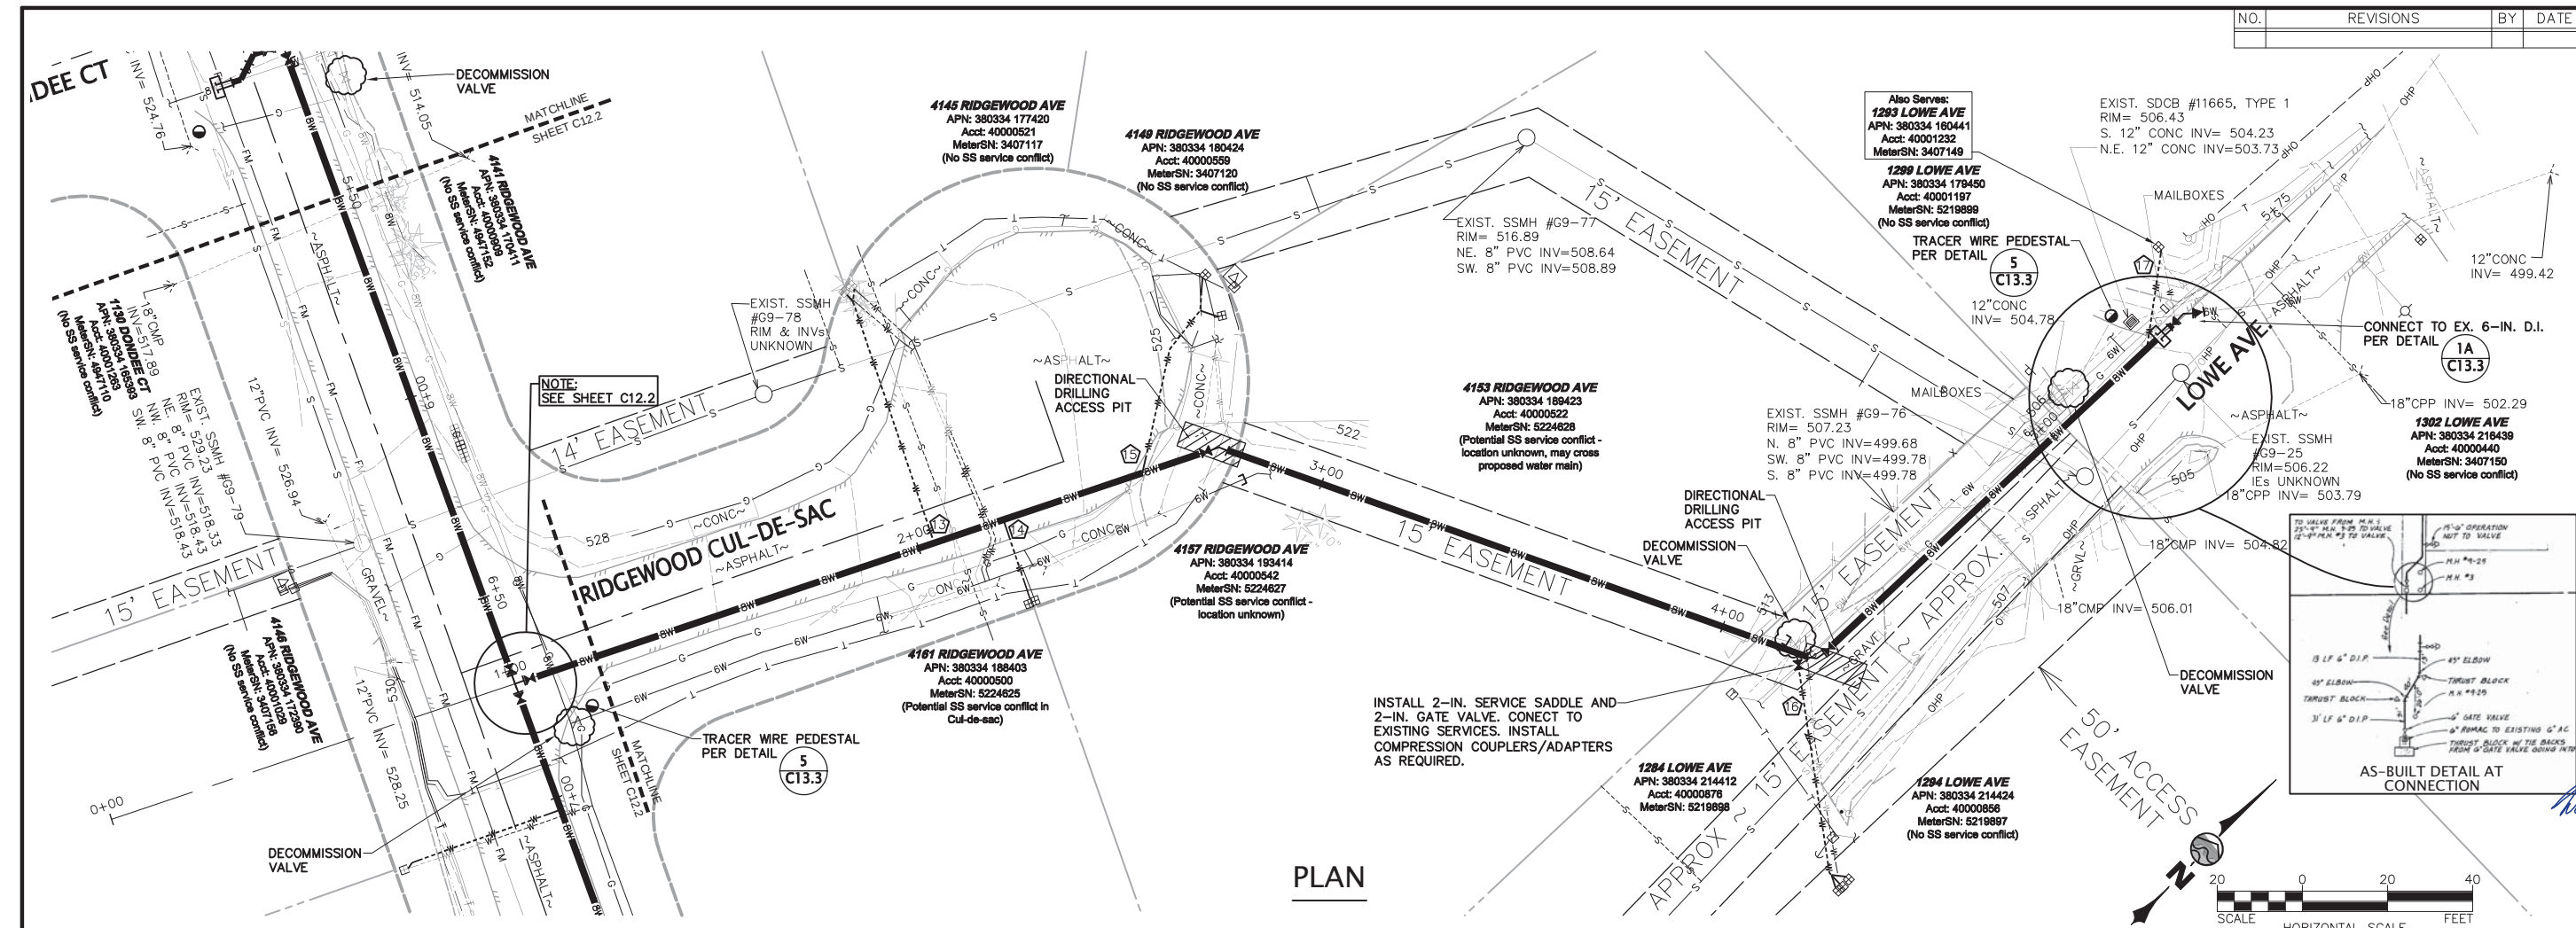

NO.	REVISIONS	BY	DATE

WILSON ENGINEERING, LLC
805 DUPONT STREET
BELLINGHAM, WA 98225
(360) 733-6100 • FAX (360) 647-9061
www.wilsonengineering.com

Wilson
SURVEY/ENGINEERING

STATE OF WASHINGTON
MELANIE M. MANKIEWICZ
35766
REGISTERED PROFESSIONAL ENGINEER

2/4/15

DESIGNED BY
MM

DRAWN BY
RDW

CHECKED BY
DNC

LAKE WHATCOM WATER & SEWER DISTRICT

WASHINGTON

BELLINGHAM

GENEVA AC MAINS REPLACEMENT PROJECT
PLAN & PROFILE - RIDGEWOOD CUL-DE-SAC
STA 1+00 TO STA 5+20

SHEET
C12.4

DATE
FEBRUARY 4, 2015

SCALE
AS SHOWN

OF
37

JOB NUMBER
2013-131