
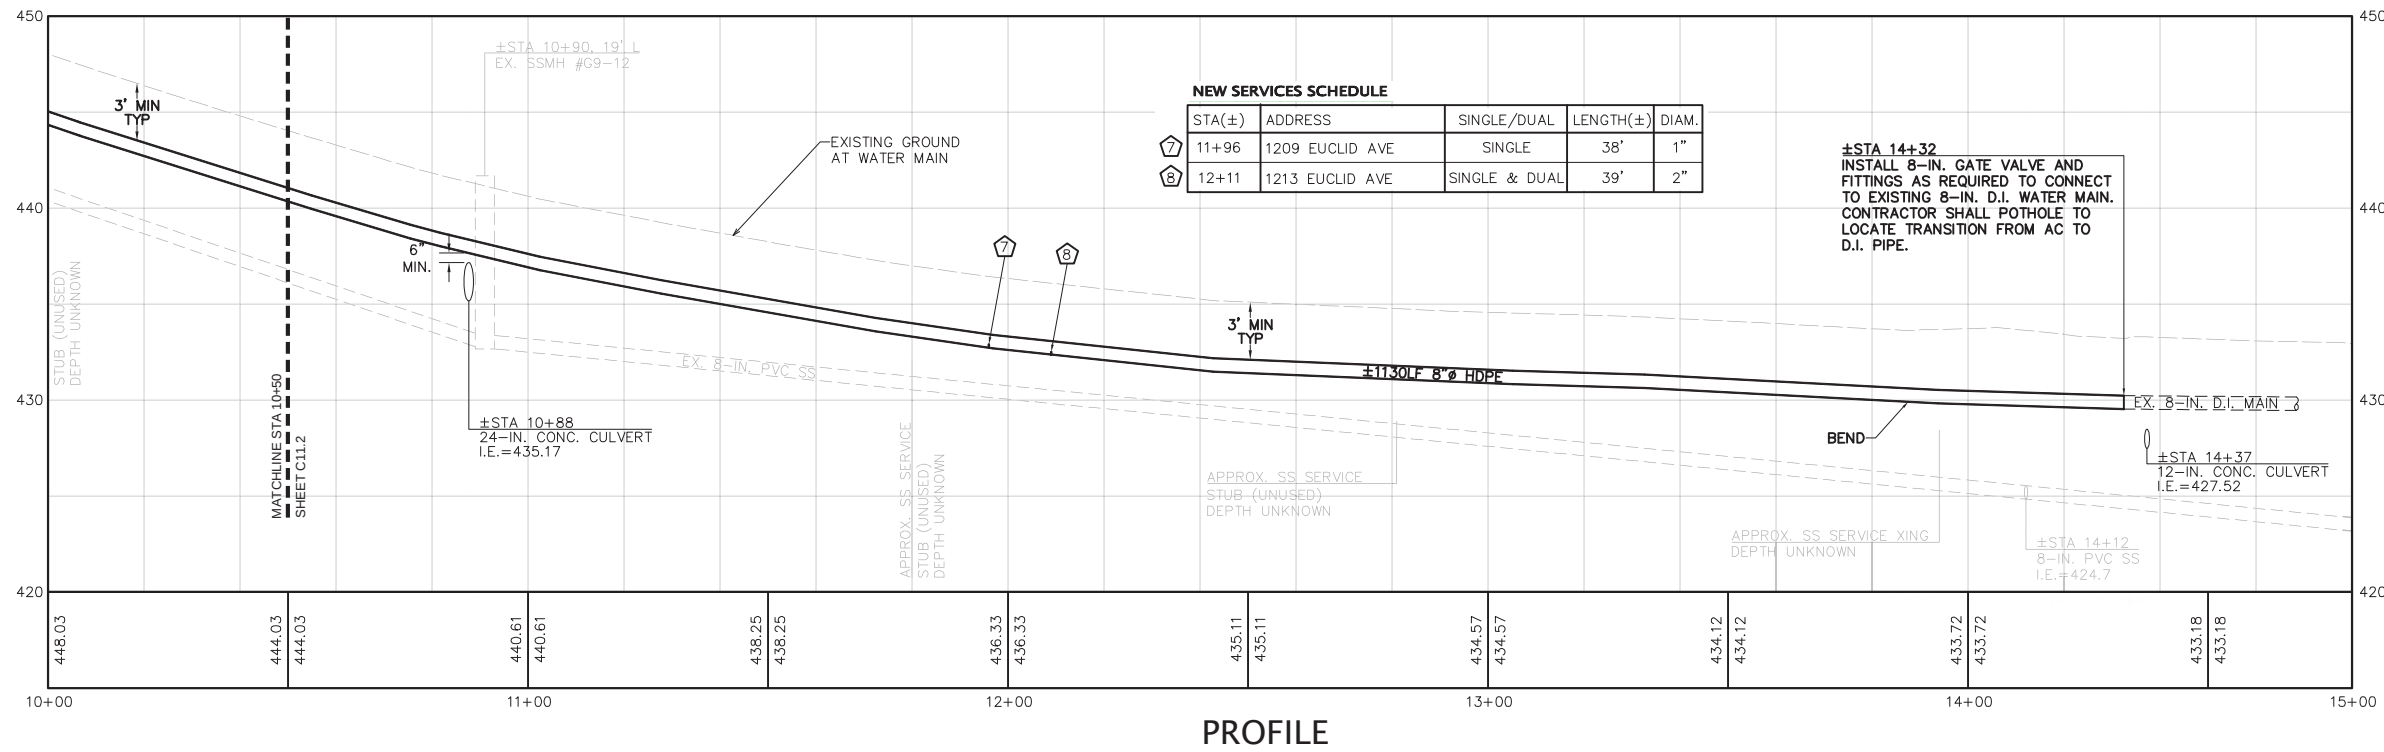


W:\2013\2013-131 LWWSD Geneva AC Mains Replacement\dwg\2013-131 C11.3 Plan and Profile Euclid So of Lakeway.dwg, 2/4/2015 12:40:37 PM, PDF-Change 2x34.pcs, RDN

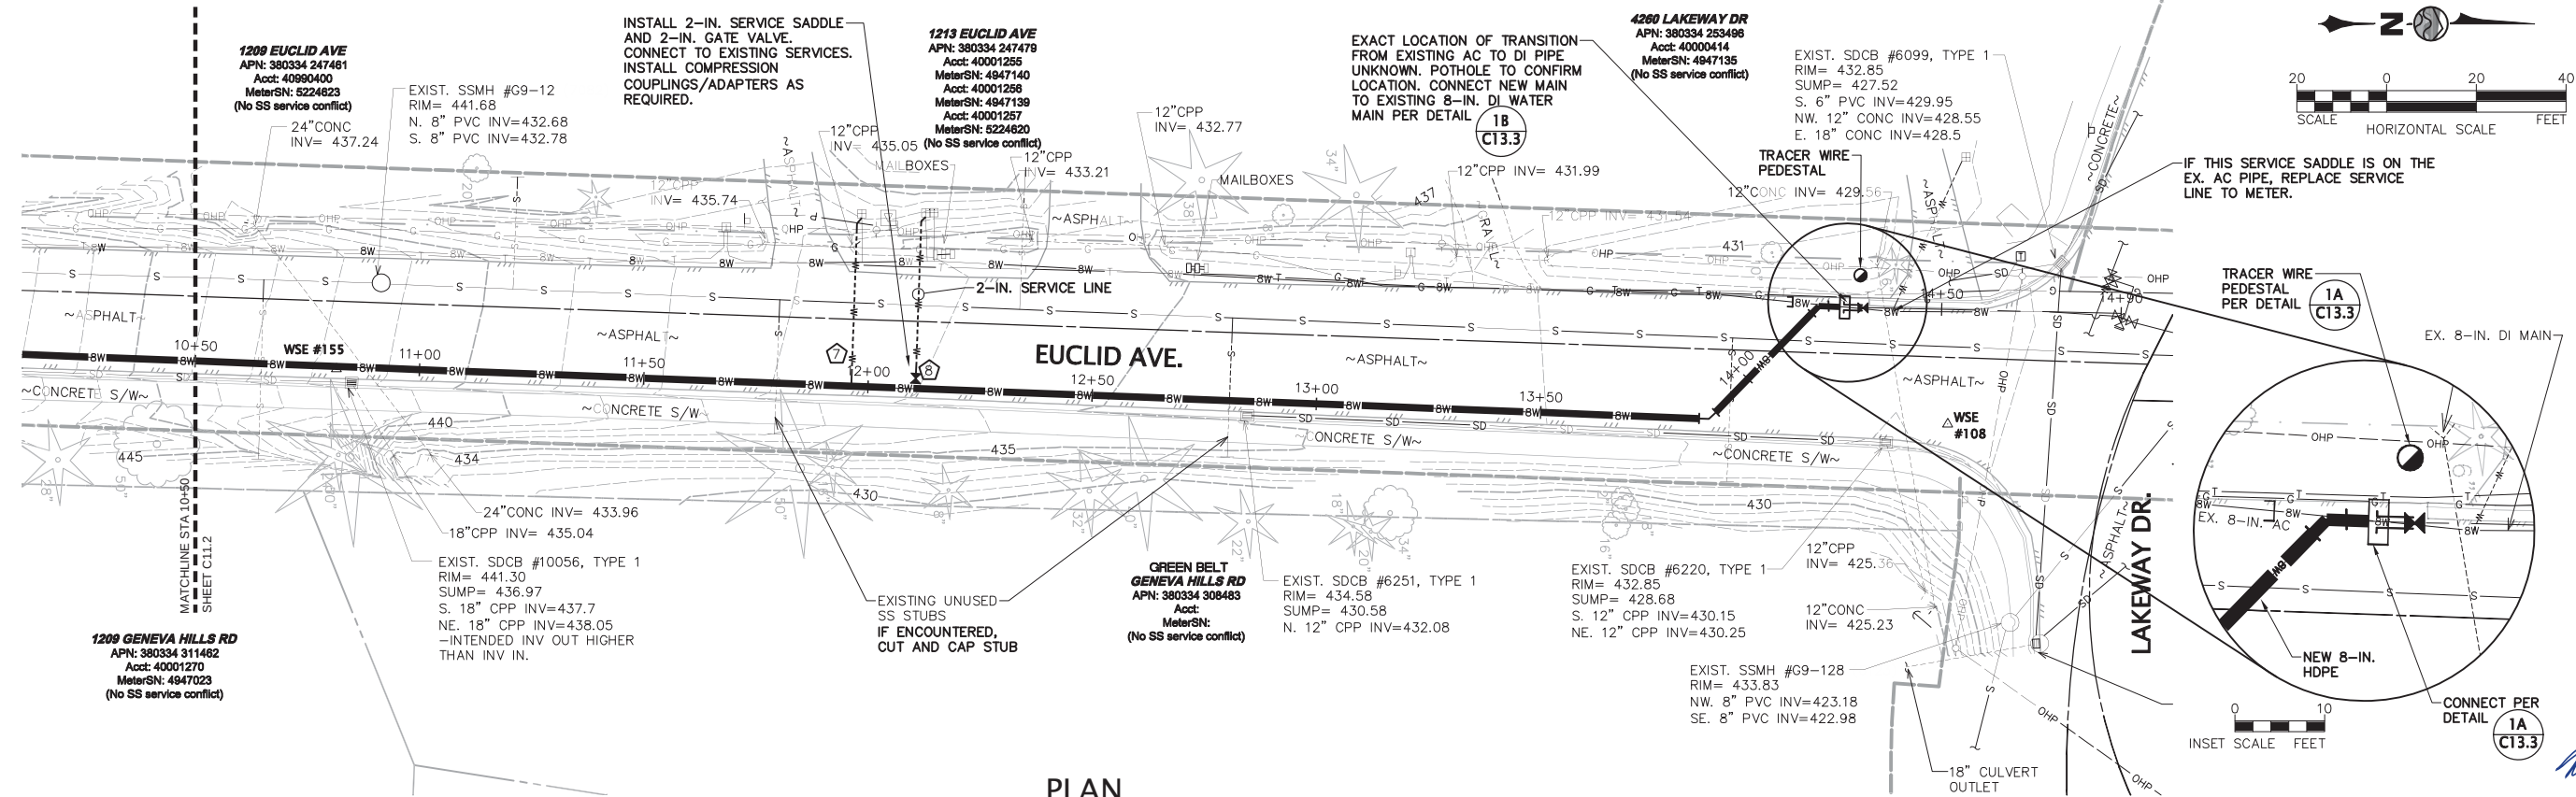

CALL
TWO BUSINESS DAYS
BEFORE YOU DIG
1-800-424-5555
UTILITIES UNDERGROUND LOCATION CENTER

NO.		REVISIONS		BY	DATE

20 0 20 40
SCALE HORIZONTAL SCALE FEET

Wilson
SURVEY/ENGINEERING

DESIGNED BY	MM	DRAWN BY	RDN	CHECKED BY	DNC

LAKE WHATCOM WATER & SEWER DISTRICT		WASHINGTON	
GENEVA AC MAINS REPLACEMENT PROJECT		BELLINGHAM	
PLAN & PROFILE - EUCLID AVE. (SO. OF LAKEWAY)			
STA 10+50 TO STA 14+35			

SHEET	DATE	SCALE	AS SHOWN	JOB NUMBER
C11.3	FEBRUARY 4, 2015	AS SHOWN		2013-131

OF	37