
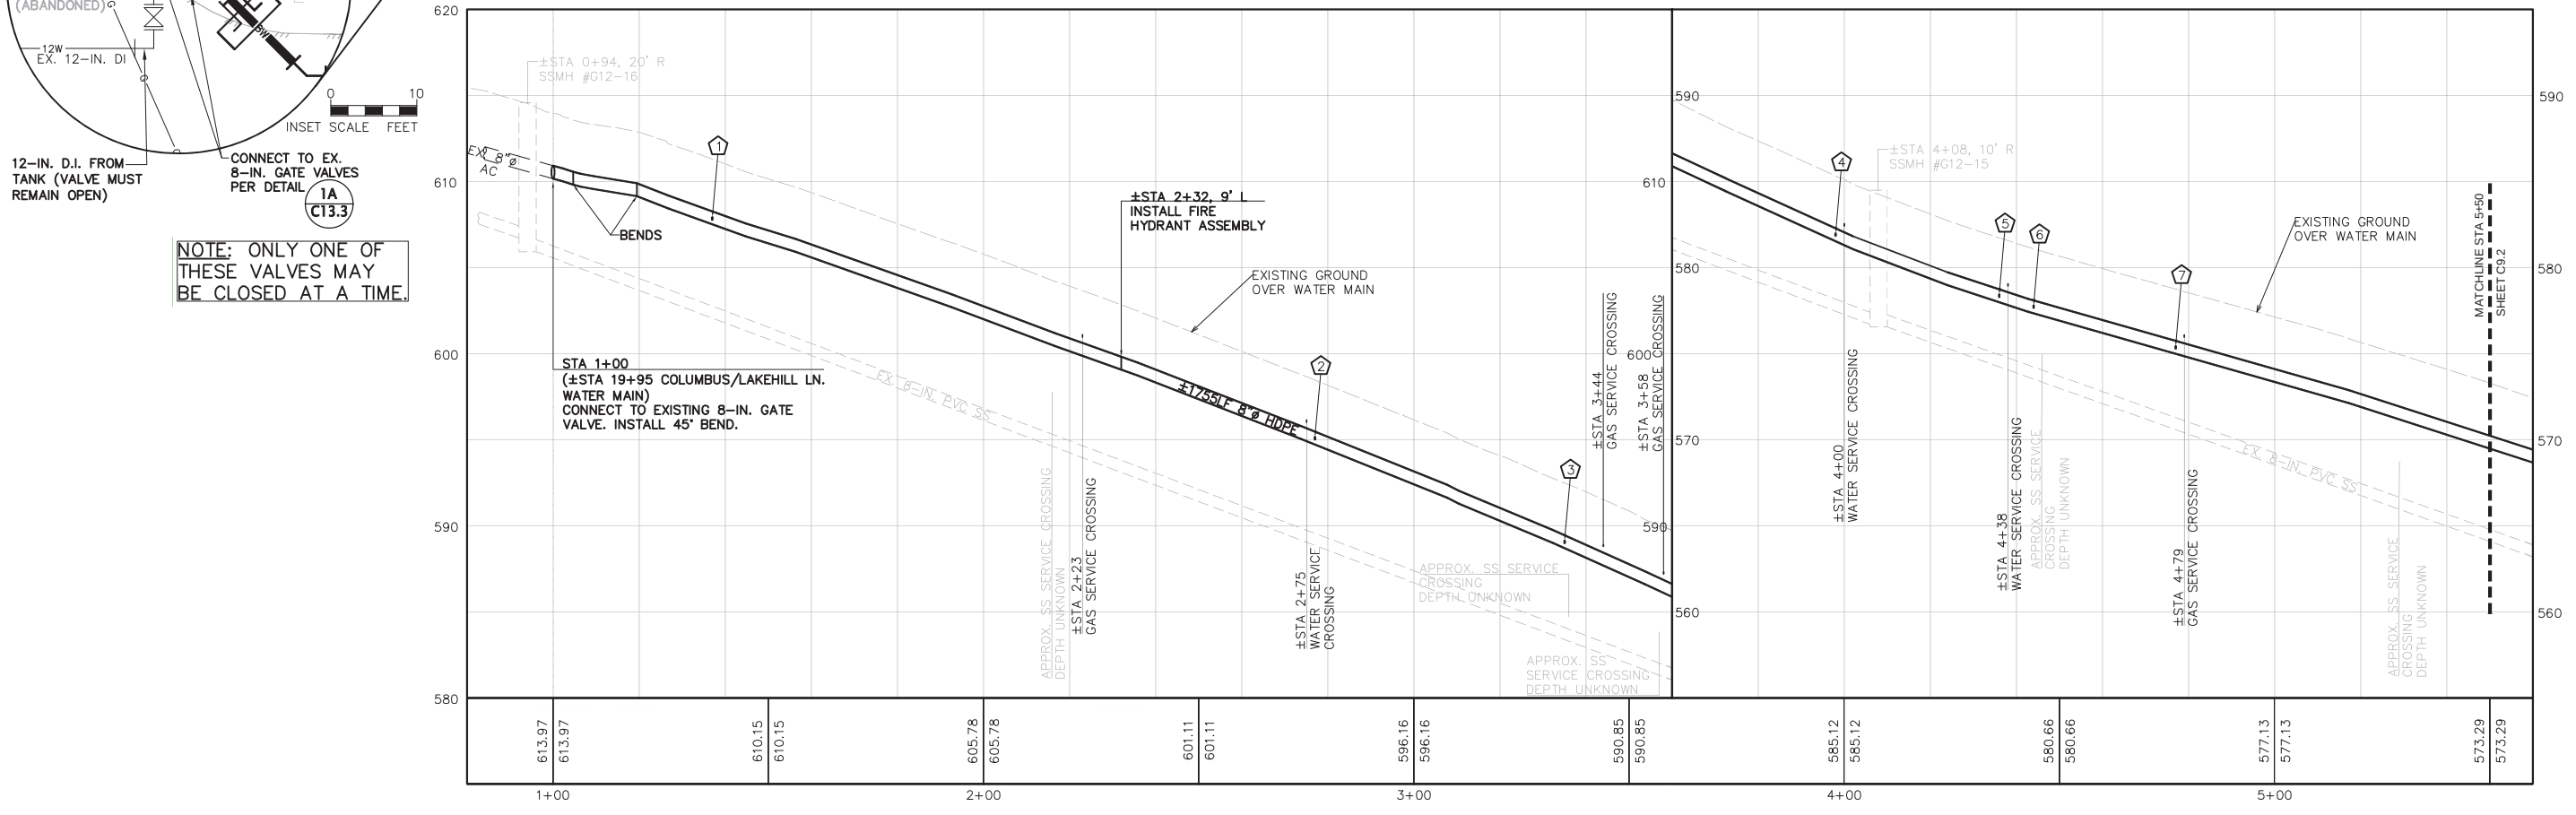


W:\2013\2013-131 LWSD Geneva AC Mains Replacement\dwg\2013-131_C9.1-C9.4 Plan and Profile Lakeview.dwg, 2/4/2015 11:31:54 AM, PDF-XChange 22x34.pcs, RDN

CALL
TWO BUSINESS DAYS
BEFORE YOU DIG
1-800-424-5555
UTILITIES UNDERGROUND LOCATION CENTER

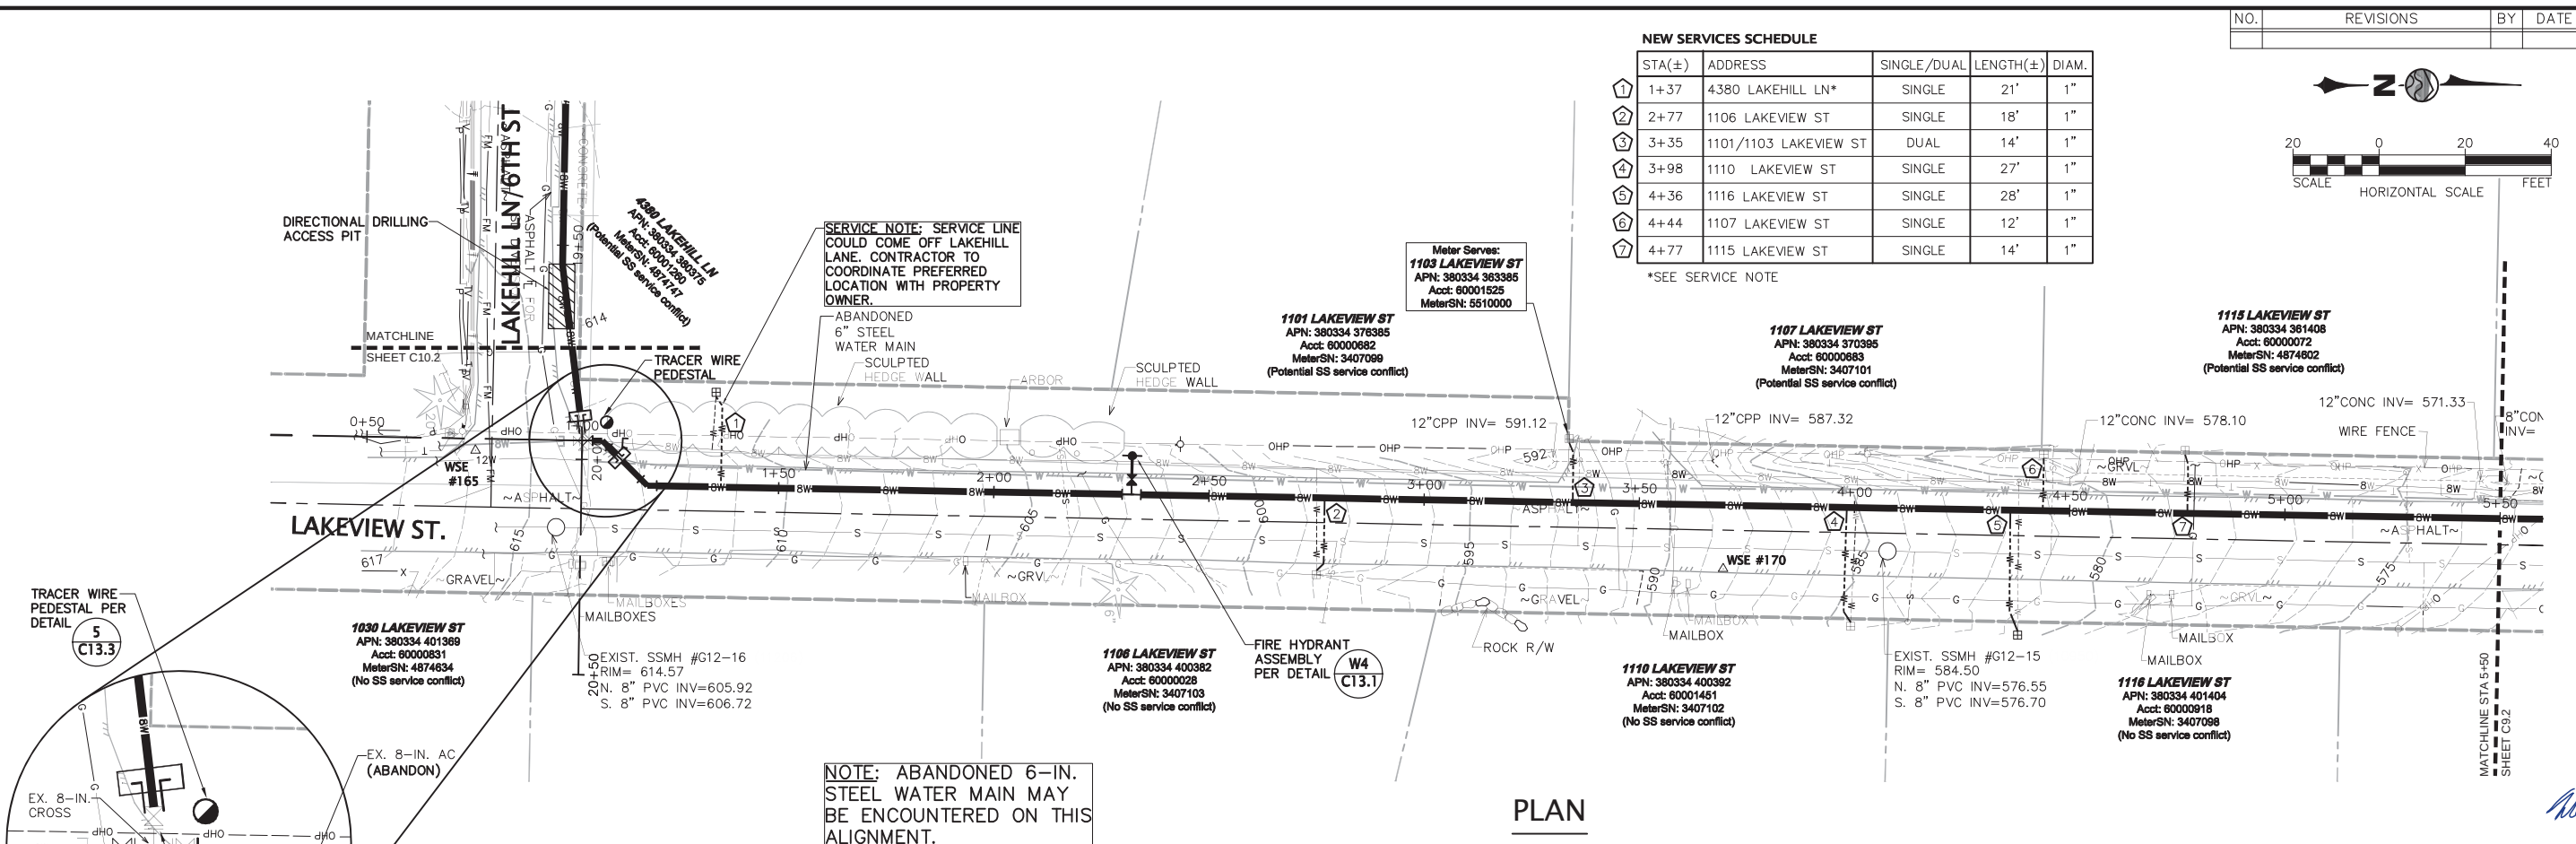

NO. REVISIONS BY DATE

WILSON ENGINEERING, LLC
805 DUPONT STREET
BELLINGHAM, WA 98225
(360) 733-6100 • FAX (360) 647-9061
www.wilsonengineering.com

Wilson
SURVEY/ENGINEERING

2/4/15

DESIGNED BY MIM
DRAWN BY RDN
CHECKED BY DNC

LAKE WHATCOM WATER & SEWER DISTRICT
WASHINGTON
GENEVA AC MAINS REPLACEMENT PROJECT
PLAN & PROFILE - LAKEVIEW STREET
STA 1+00 TO STA 5+50


DATE
FEBRUARY 4, 2015

SCALE
AS SHOWN

JOB NUMBER
2013-131


C9.1
OF
37

W:\2013\2013-131 LWWSD Geneva AC Mains Replacement.dwg\2013-131 C9.1-C9.4 Plan and Profile Lakeview.dwg, 2/4/2015 11:39:18 AM, PDF->Change 22x34.pcs, RDN

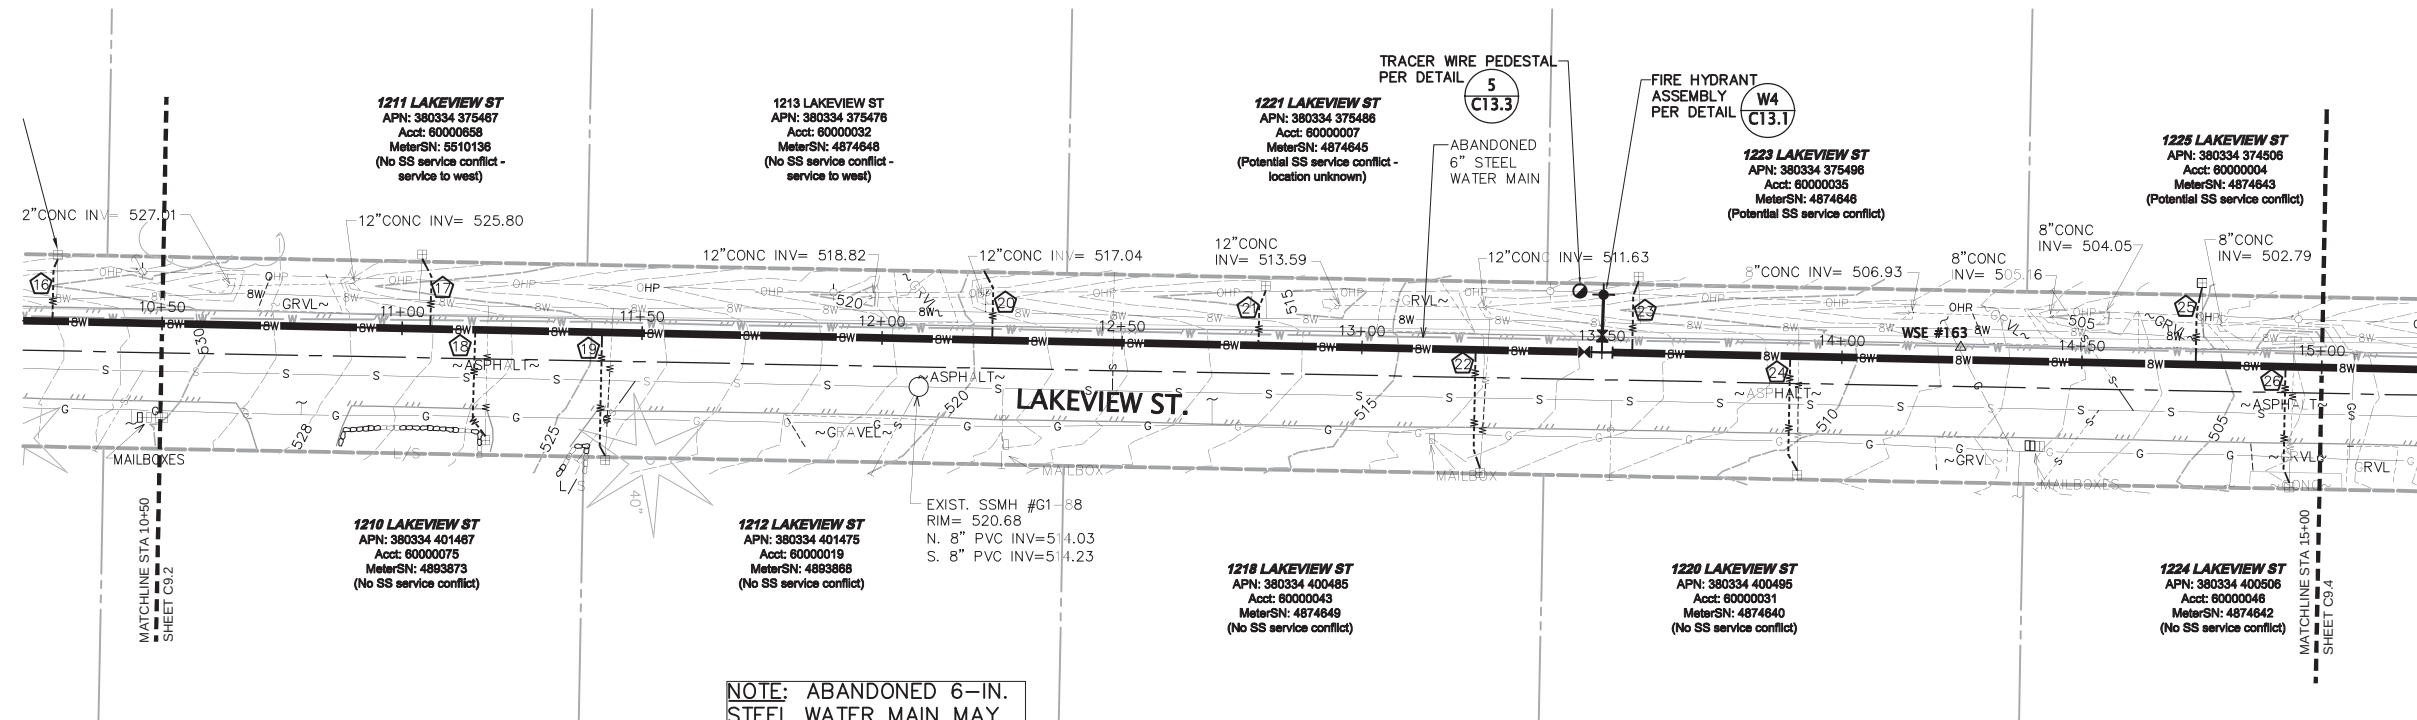


NOTE: ABANDONED 6-IN. STEEL WATER MAIN MAY BE ENCOUNTERED ON THIS ALIGNMENT.

PLAN

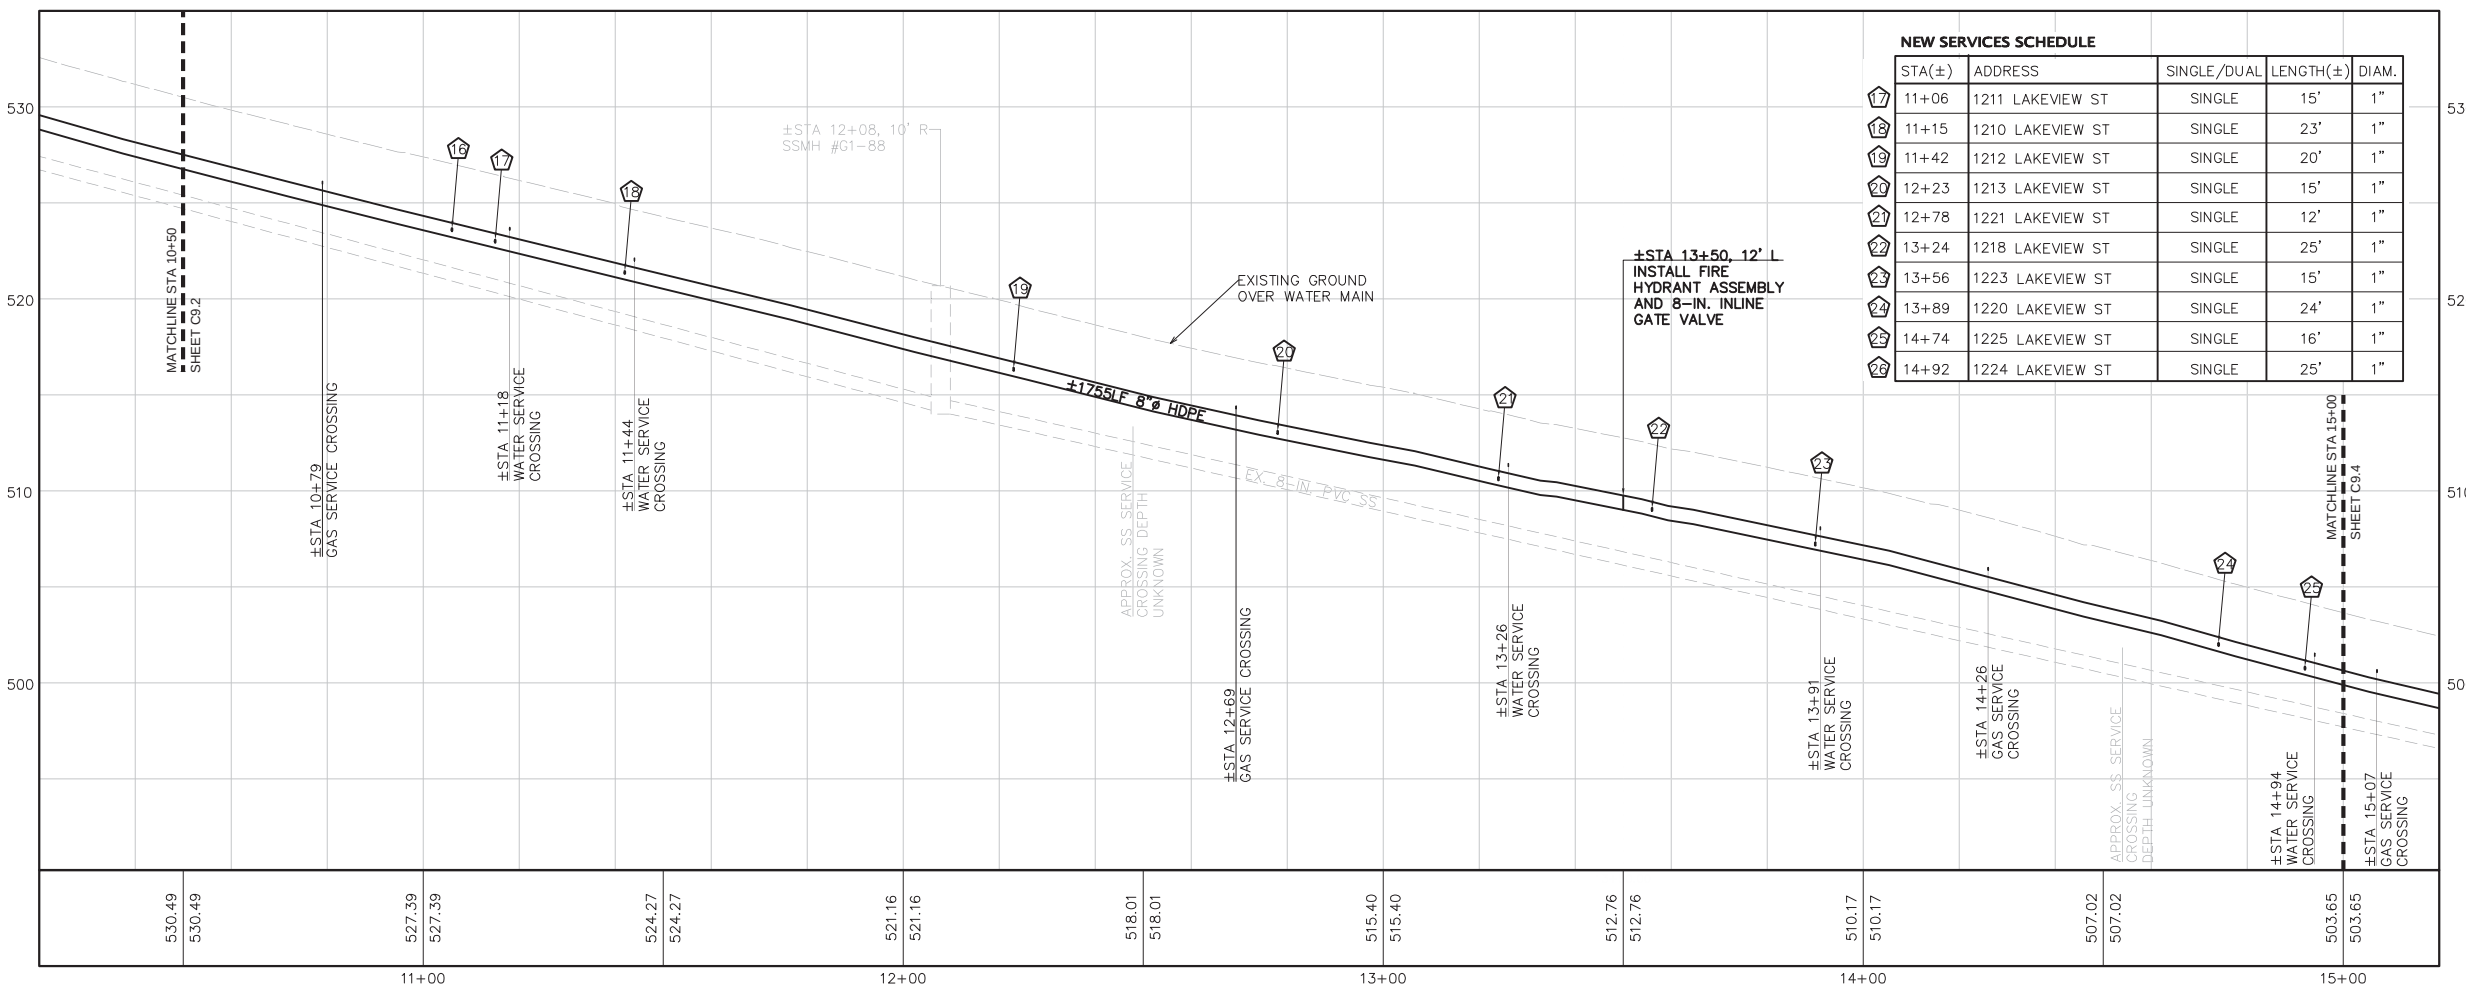

NEW SERVICES SCHEDULE				
STA(±)	ADDRESS	SINGLE/DUAL	LENGTH(±)	DIAM.
11+06	1211 LAKEVIEW ST	SINGLE	15'	1"
11+15	1210 LAKEVIEW ST	SINGLE	23'	1"
11+42	1212 LAKEVIEW ST	SINGLE	20'	1"
12+23	1213 LAKEVIEW ST	SINGLE	15'	1"
12+78	1221 LAKEVIEW ST	SINGLE	12'	1"
13+24	1218 LAKEVIEW ST	SINGLE	25'	1"
13+56	1223 LAKEVIEW ST	SINGLE	15'	1"
13+89	1220 LAKEVIEW ST	SINGLE	24'	1"
14+74	1225 LAKEVIEW ST	SINGLE	16'	1"
14+92	1224 LAKEVIEW ST	SINGLE	25'	1"

PROFILE

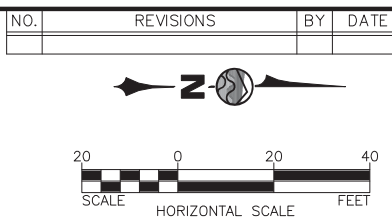

NO. REVISIONS BY DATE

WILSON ENGINEERING, LLC
805 DUPONT STREET
BELLINGHAM, WA 98225
(360) 733-6100 • FAX (360) 647-9061
www.wilsonengineering.com

Wilson
SURVEY/ENGINEERING

2/4/15

DESIGNED BY: MIM
DRAWN BY: RDN
CHECKED BY: DNC

LAKE WHATCOM WATER & SEWER DISTRICT
GENEVA AC MAINS REPLACEMENT PROJECT
PLAN & PROFILE - LAKEVIEW STREET
STA 10+00 TO STA 15+00


DATE: FEBRUARY 4, 2015
SCALE: AS SHOWN
JOB NUMBER: 2013-131

C9.3
OF
37


CALL TWO BUSINESS DAYS BEFORE YOU DIG
1-800-424-5555
UTILITIES UNDERGROUND LOCATION CENTER

W:\2013\2013-131 LWWSD Geneva AC Mains Replacement\dwg\2013-131_C9_1-C9.4 Plan and Profile Lakeview.dwg, 2/4/2015 11:39:43 AM, PDF-XChange 22x34.pcs, RDN

NOTE: ABANDONED 6-IN. STEEL WATER MAIN MAY BE ENCOUNTERED ON THIS ALIGNMENT.

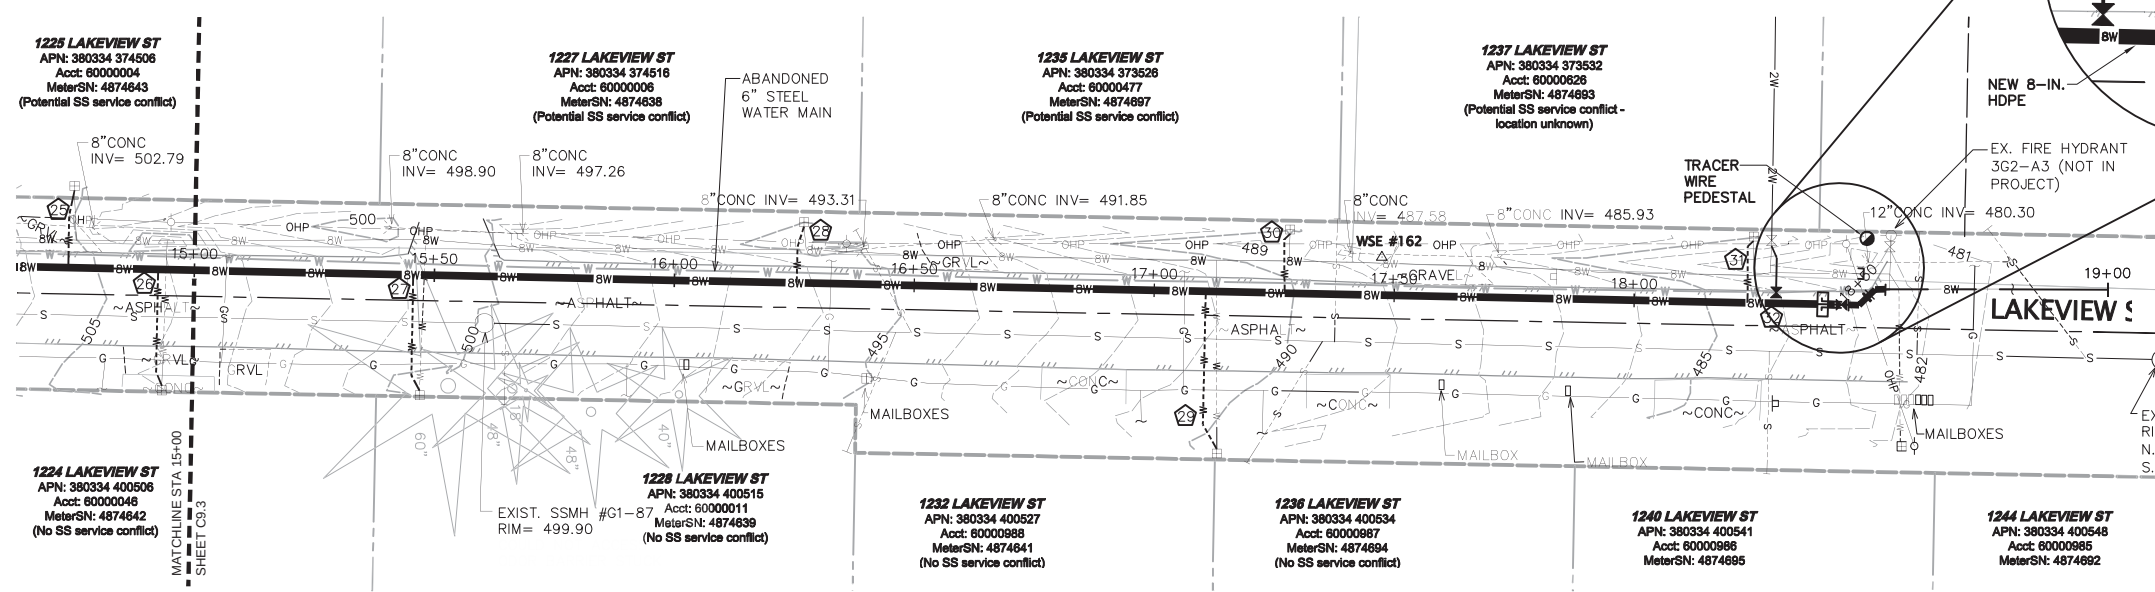

PLAN

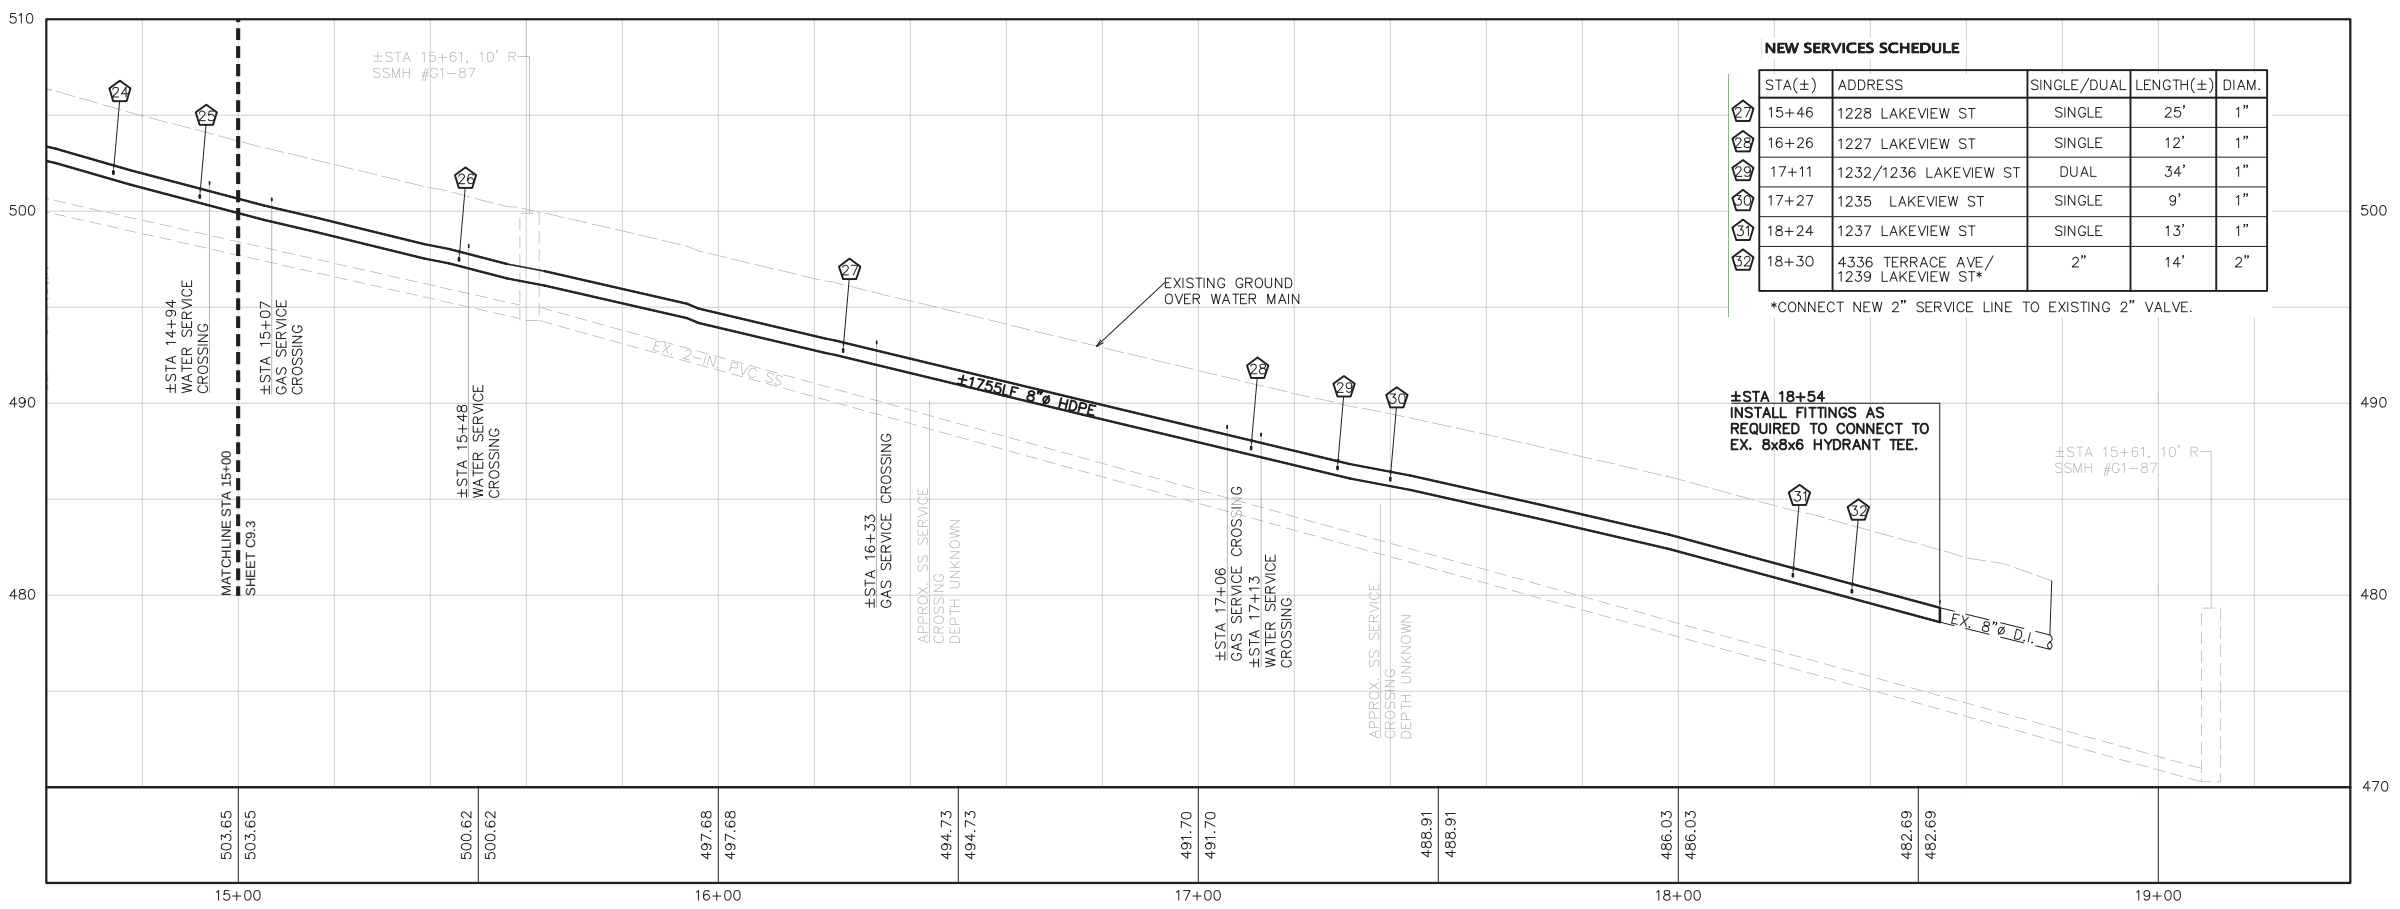

NEW SERVICES SCHEDULE				
STA(±)	ADDRESS	SINGLE/DUAL	LENGTH(±)	DIAM.
15+46	1228 LAKEVIEW ST	SINGLE	25'	1"
16+26	1227 LAKEVIEW ST	SINGLE	12'	1"
17+11	1232/1236 LAKEVIEW ST	DUAL	34'	1"
17+27	1235 LAKEVIEW ST	SINGLE	9'	1"
18+24	1237 LAKEVIEW ST	SINGLE	13'	1"
18+30	4336 TERRACE AVE/ 1239 LAKEVIEW ST*	2"	14'	2"

*CONNECT NEW 2" SERVICE LINE TO EXISTING 2" VALVE.

±STA 18+54
INSTALL FITTINGS AS
REQUIRED TO CONNECT TO
EX. 8x8x6 HYDRANT TEE.

PROFILE - LAKEVIEW STREET

NO. REVISIONS BY DATE

SCALE
HORIZONTAL SCALE
INSET SCALE

WILSON ENGINEERING, LLC
805 DUPONT STREET
BELLINGHAM, WA 98225
(360) 733-6100 • FAX (360) 647-9061
www.wilsonengineering.com

SURVEY/ENGINEERING

274775

DESIGNED BY MIM
DRAWN BY RDN
CHECKED BY DNC

LAKE WHATCOM WATER & SEWER DISTRICT
WASHINGTON
GENEVA AC MAINS REPLACEMENT PROJECT
PLAN & PROFILE - LAKEVIEW STREET
STA 15+00 TO STA 18+50

DATE
FEBRUARY 4, 2015
SCALE
AS SHOWN
JOB NUMBER
2013-131

SHEET
C9.4
OF
37

CALL
TWO BUSINESS DAYS
BEFORE YOU DIG
1-800-424-5555
UTILITIES UNDERGROUND LOCATION CENTER