
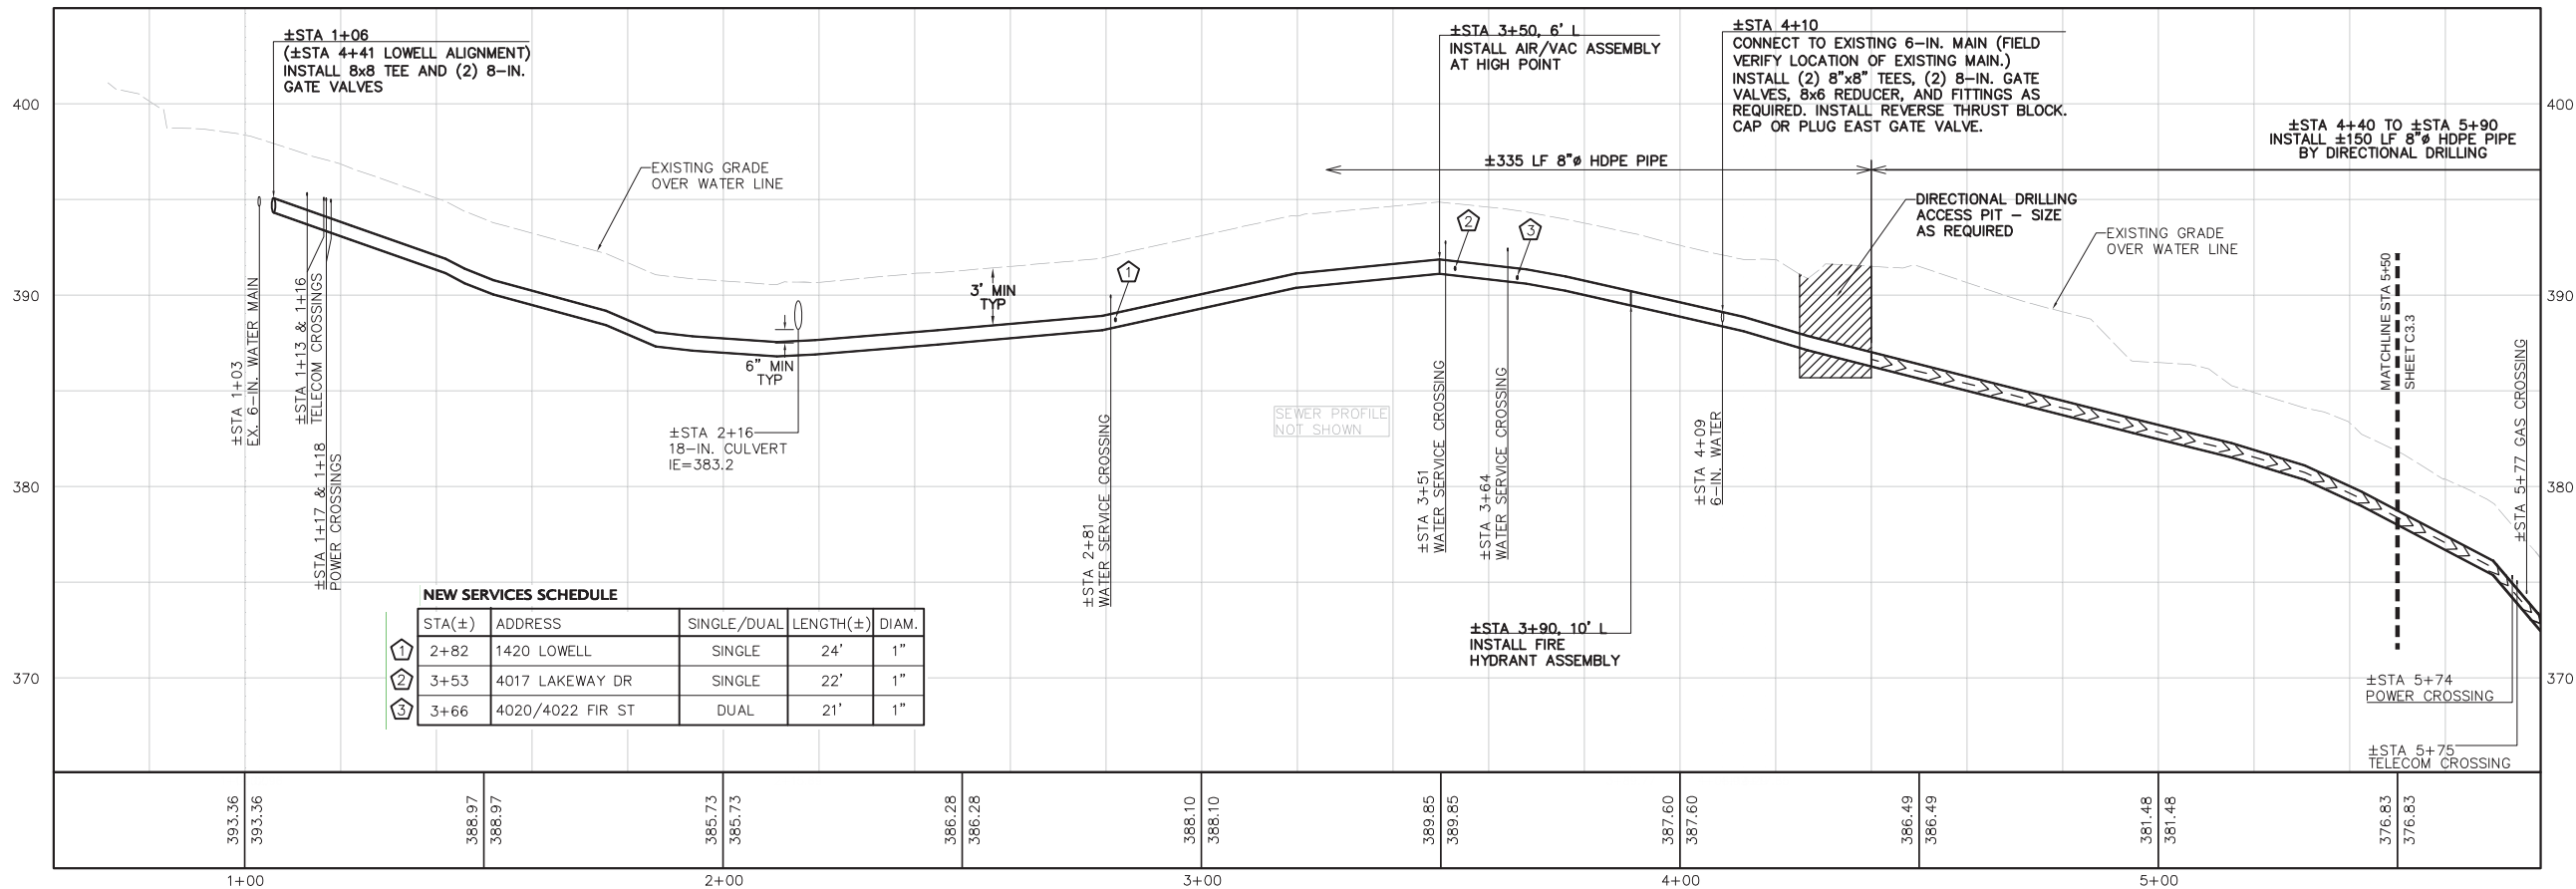


W:\2013\2013-131 LWWSD Geneva AC Mains Replacement\dwg\20-13-131_C3.1-C3.4_Plan and Profile_Lowell-Willowbrook.dwg, 2/4/2015 11:10:20 AM, PDF-Change: 2234, pc3, RON

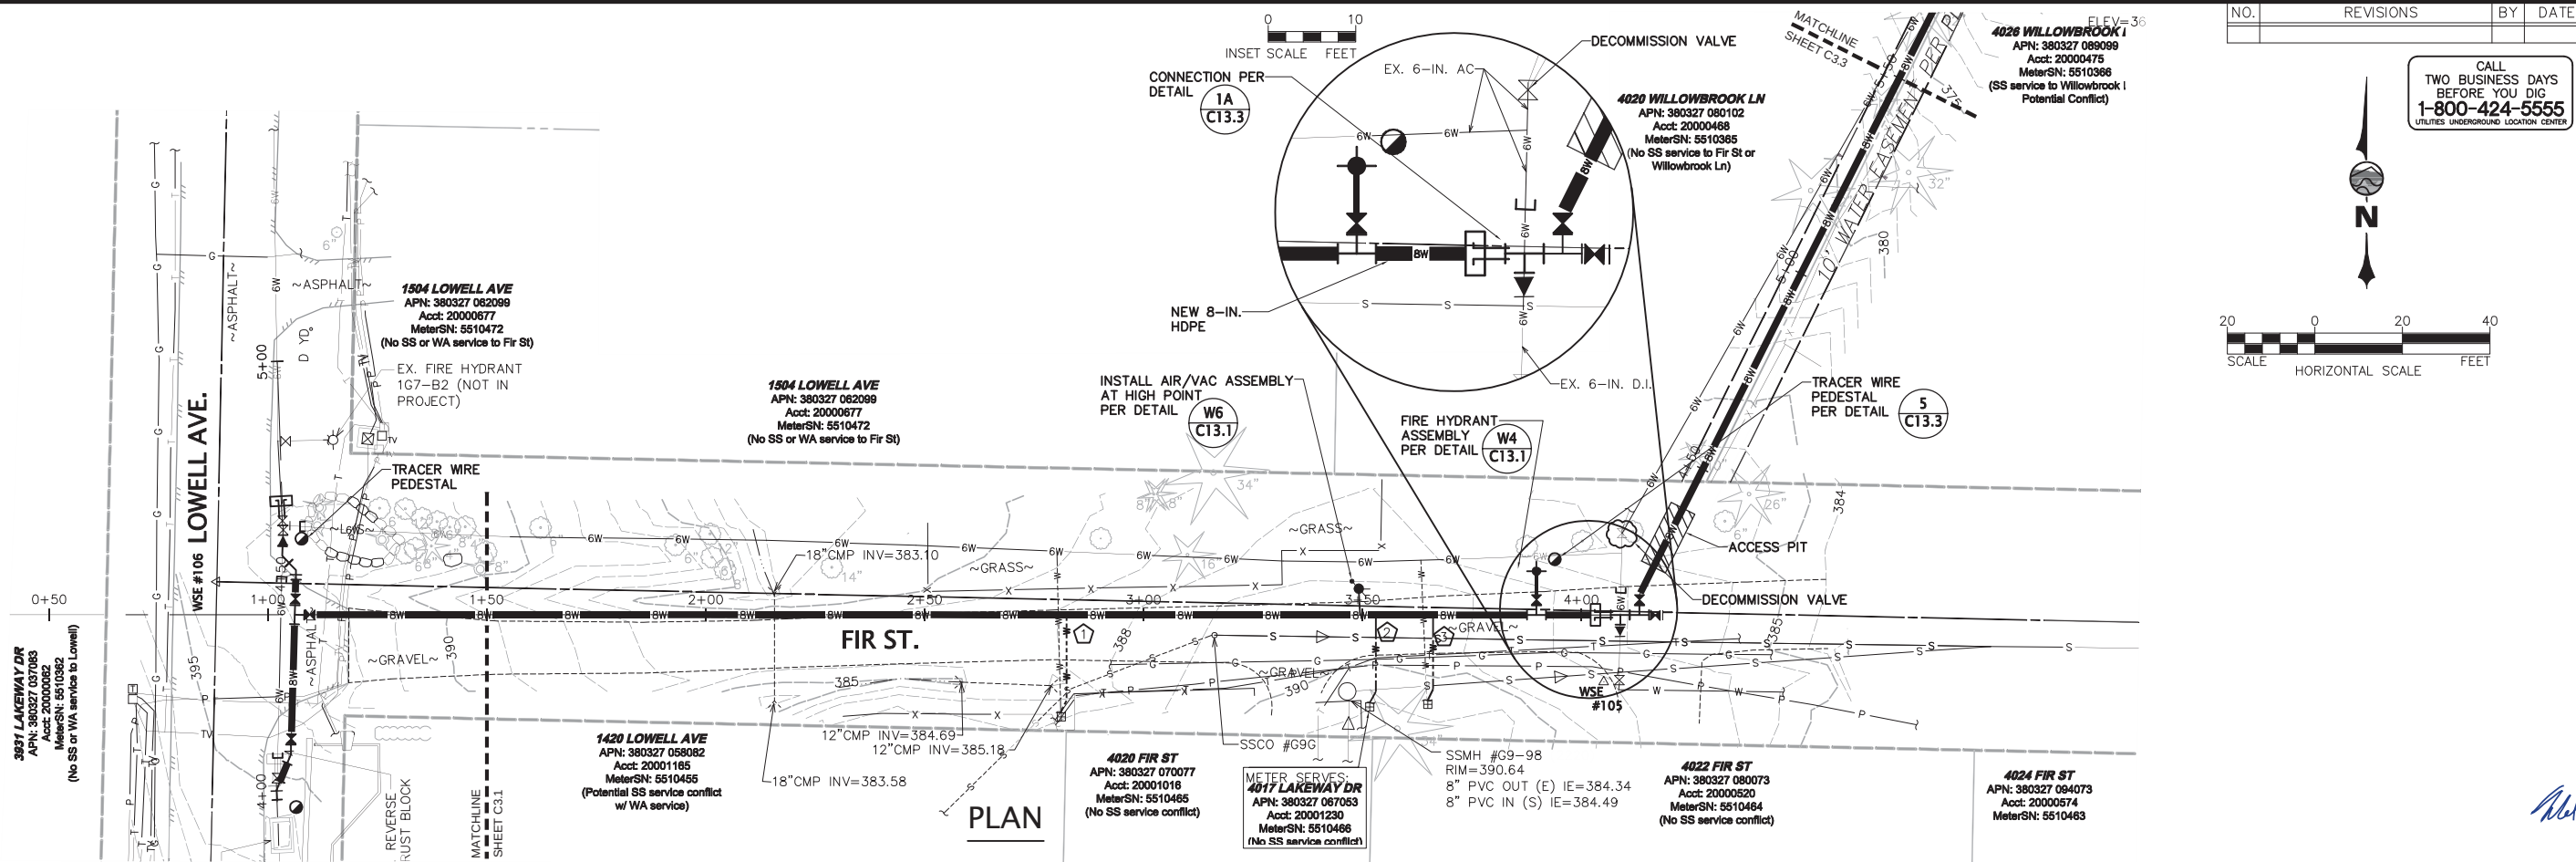

WILSON ENGINEERING, LLC
805 DUPONT STREET
BELLINGHAM, WA 98225
(360) 733-6100 • FAX (360) 647-9061
www.wilsonengineering.com

Wilson
SURVEY/ENGINEERING

STATE OF WASHINGTON
JULIANNE M. MARKHAM
35766
REGISTERED PROFESSIONAL ENGINEER

DESIGNED BY MIM
DRAWN BY RDN
CHECKED BY DNC

LAKE WHATCOM WATER & SEWER DISTRICT

WASHINGTON
GENEVA AC MAINS REPLACEMENT PROJECT
PLAN & PROFILE - FIR ST / WILLOWBROOK LN
STA 1+00 TO STA 5+50


DATE
FEBRUARY 4, 2015

SCALE
AS SHOWN


JOB NUMBER
2013-131

SHEET
C3.2
OF
37

W:\2013\2013-131 LWWSD Geneva AC Mains Replacement\dwg\2013-131 C3.1-C3.4 Plan and Profile Lowell-Willowbrook.dwg, 2/4/2015 11:10:48 AM, PDF-Change 2234, pc3, RDN

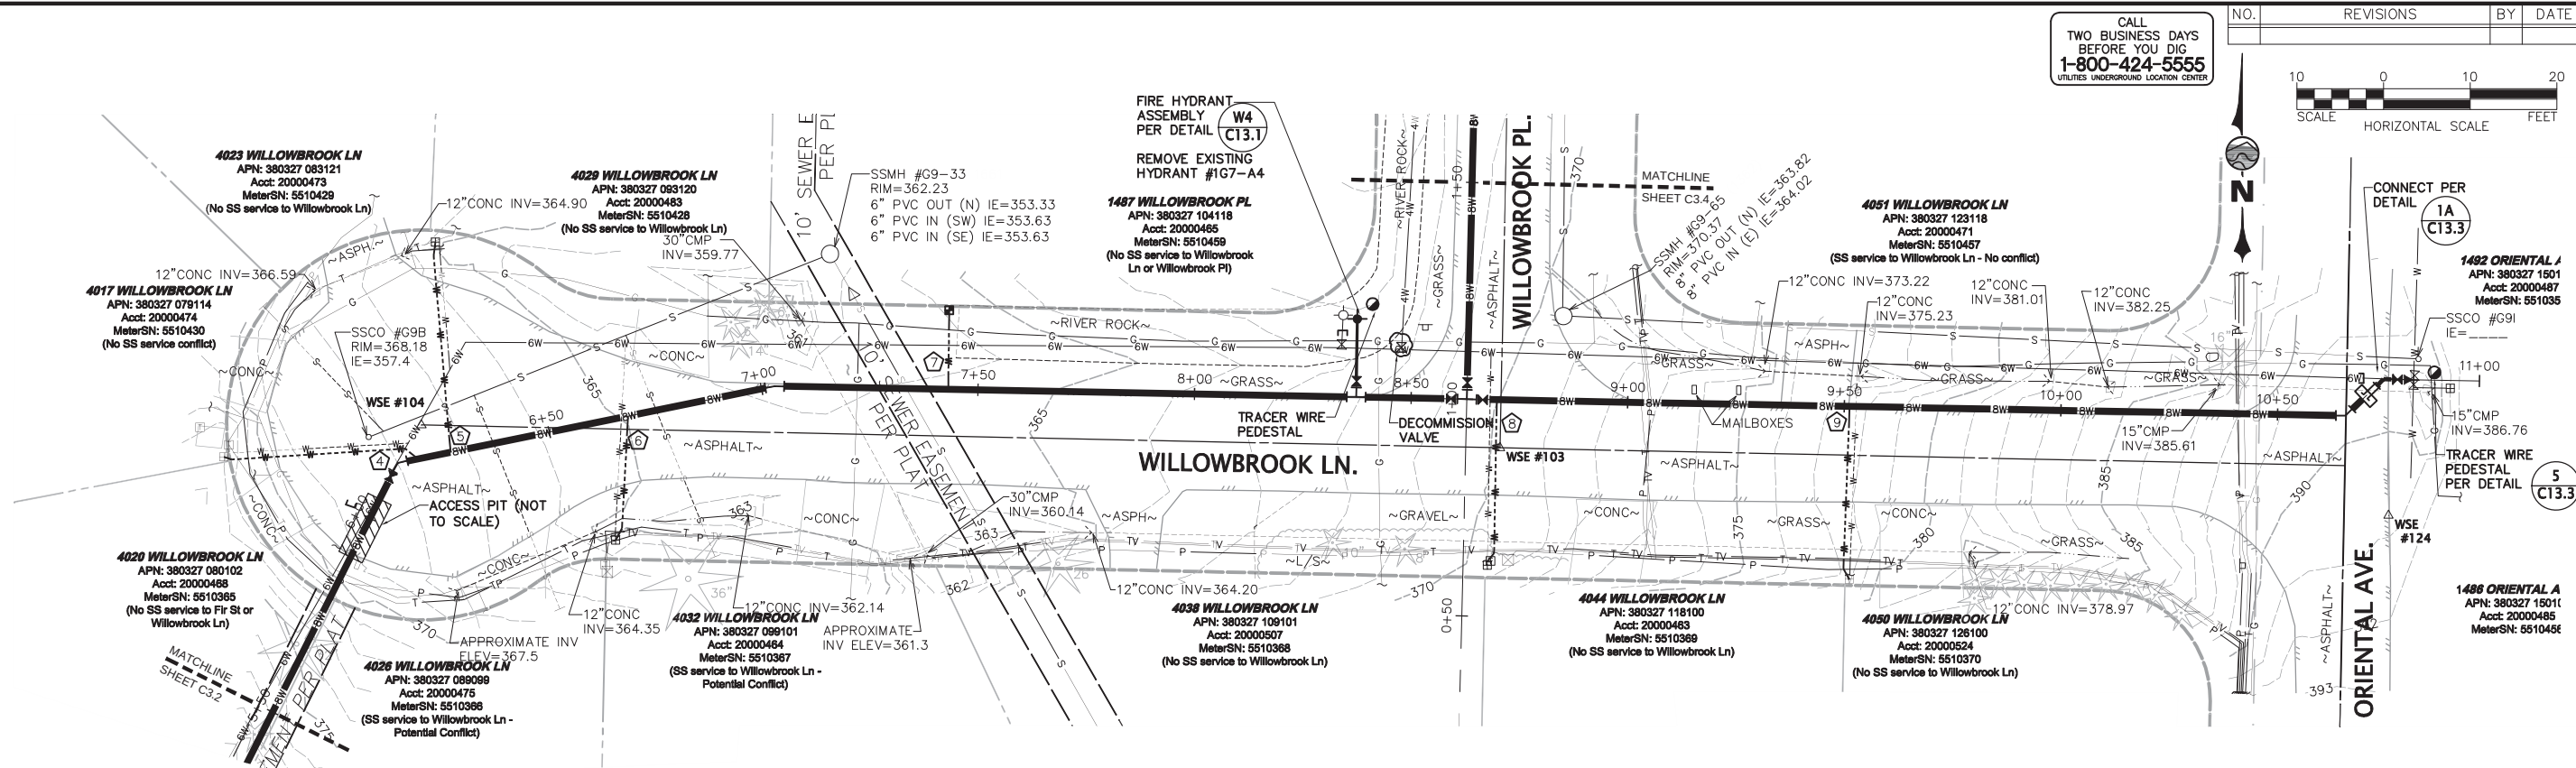

PLAN

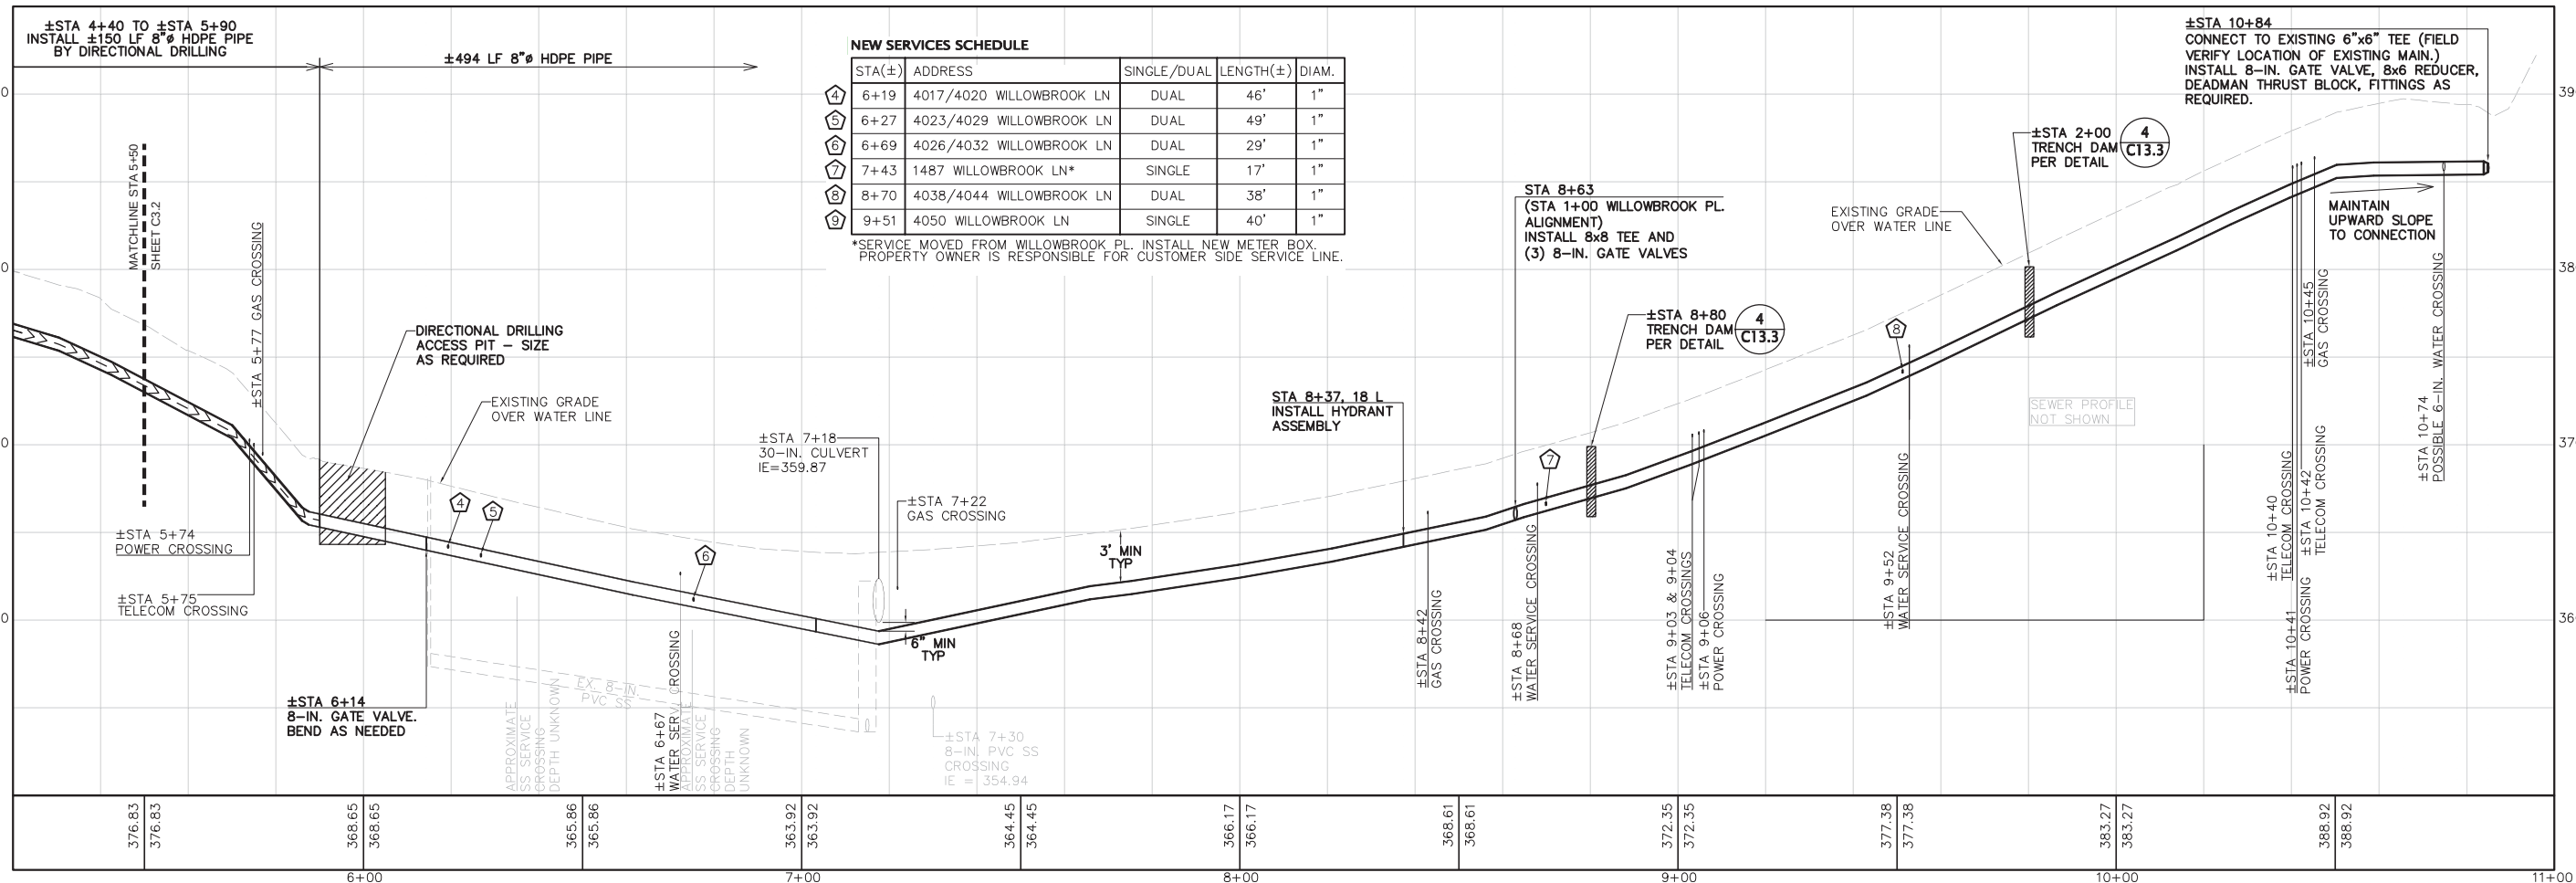

PROFILE - WILLOWBROOK LANE

NEW SERVICES SCHEDULE

STA(±)	ADDRESS	SINGLE/DUAL	LENGTH(±)	DIAM.
4	6+19 4017/4020 WILLOWBROOK LN	DUAL	46'	1"
5	6+27 4023/4029 WILLOWBROOK LN	DUAL	49'	1"
6	6+69 4026/4032 WILLOWBROOK LN	DUAL	29'	1"
7	7+43 1487 WILLOWBROOK LN*	SINGLE	17'	1"
8	8+70 4038/4044 WILLOWBROOK LN	DUAL	38'	1"
9	9+51 4050 WILLOWBROOK LN	SINGLE	40'	1"

*SERVICE MOVED FROM WILLOWBROOK PL. INSTALL NEW METER BOX. PROPERTY OWNER IS RESPONSIBLE FOR CUSTOMER SIDE SERVICE LINE.

WILSON ENGINEERING, LLC
805 DUPONT STREET
BELLINGHAM, WA 98225
(360) 733-6100 • FAX (360) 647-9061
www.wilsonengineering.com

Wilson
SURVEY/ENGINEERING

2/4/15



DESIGNED BY: MIM
DRAWN BY: RDN
CHECKED BY: DNC

LAKE WHATCOM WATER & SEWER DISTRICT
GENEVA AC MAINS REPLACEMENT PROJECT
PLAN & PROFILE - LOWELL AVE/FIR ST/ WILLOWBROOK LN
STA 5+50 TO STA 10+85

DATE: FEBRUARY 4, 2015
SCALE: AS SHOWN
JOB NUMBER: 2013-131

C3.3
OF
37

W:\2013\2013-131 LWWSD Geneva AC Mains Replacement\dwg\2013-131 C3.1-C3.4 Plan and Profile Lowell-Willowbrook.dwg, 2/4/2015 11:11:16 AM, PDF-Change 2234.pcl, RDN

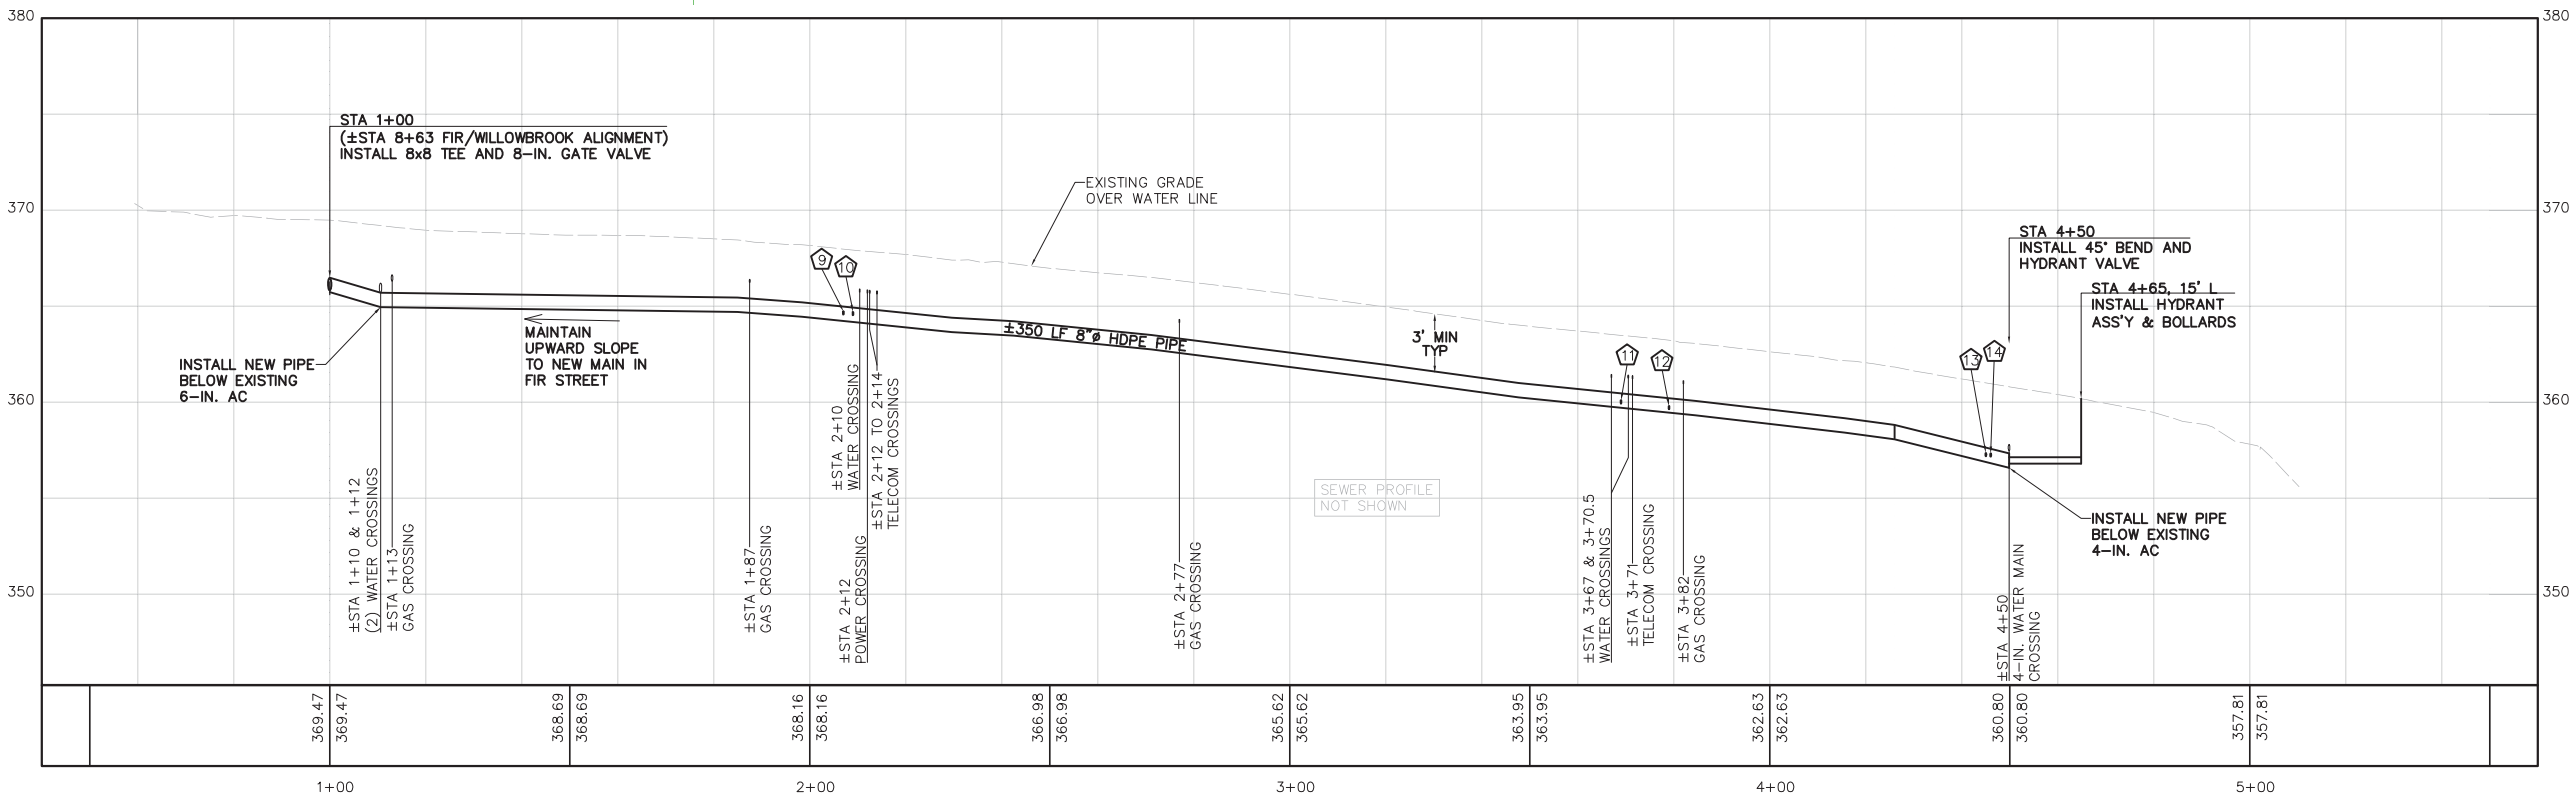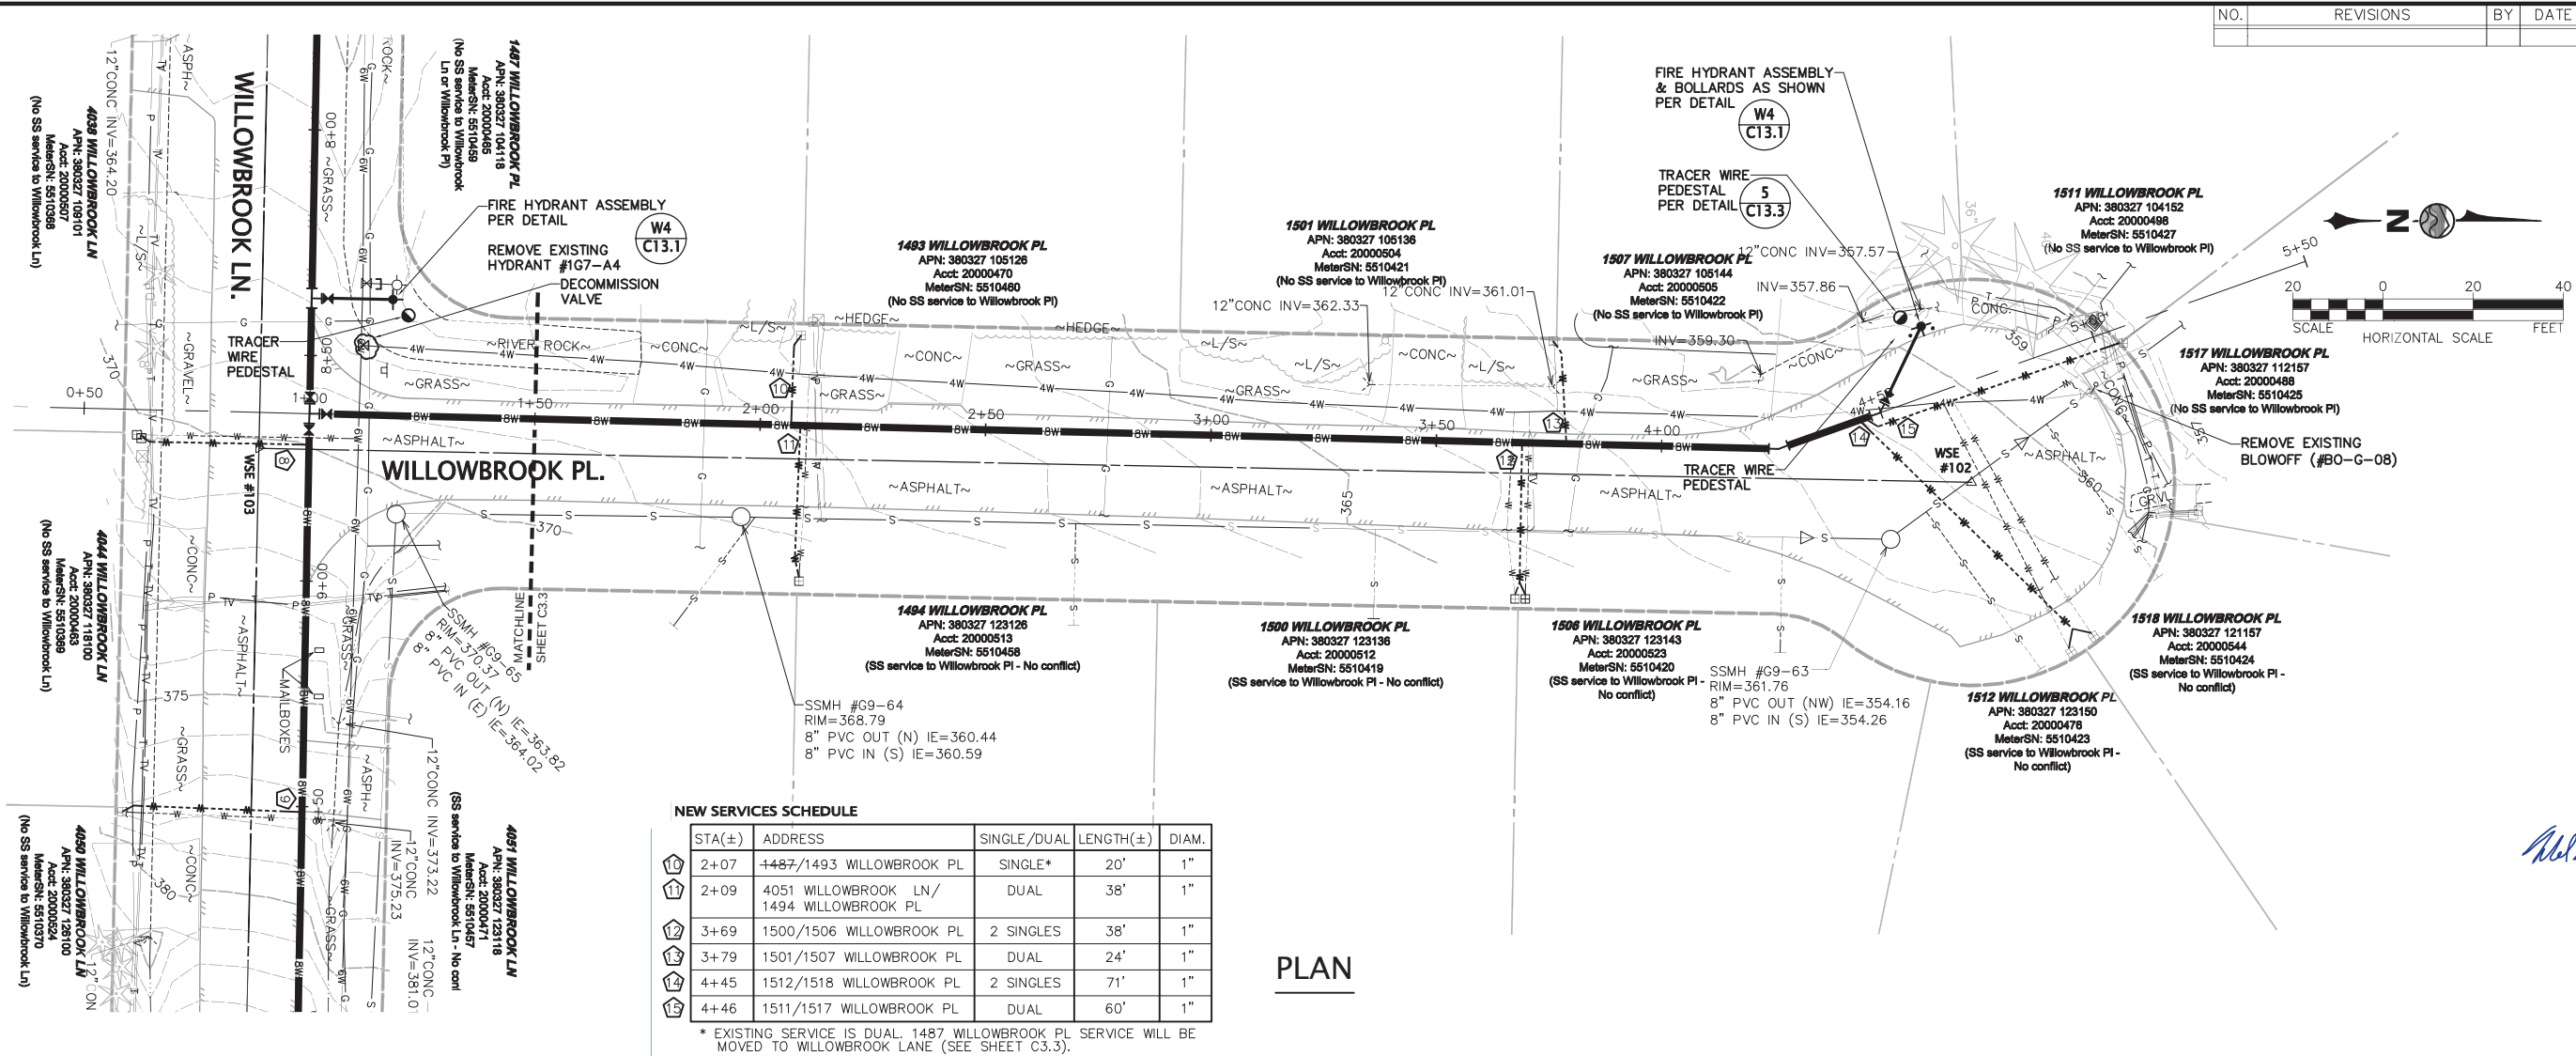

CALL
TWO BUSINESS DAYS
BEFORE YOU DIG
1-800-424-5555
UTILITIES UNDERGROUND LOCATION CENTER

LAKE WHATCOM WATER & SEWER DISTRICT

DATE
FEBRUARY 4, 2015

SHEET
C3.4

WASHINGTON

SCALE
AS SHOWN

OF
37

GENEVA AC MAINS REPLACEMENT PROJECT
PLAN & PROFILE - WILLOWBROOK PLACE
STA 1+00 TO STA 4+65

JOB NUMBER
2013-131

DESIGNED BY
MM

DRAWN BY
RDN

CHECKED BY
DNC

2/4/15

MELANIE M. MARKHAM
STATE OF WASHINGTON
REGISTERED
PROFESSIONAL ENGINEER
33766

WILSON ENGINEERING, LLC
805 DUPONT STREET
BELLINGHAM, WA 98225
(360) 733-6100 • FAX (360) 647-9061
www.wilsonengineering.com

WILSON
SURVEY/ENGINEERING