



W:\2013\2013-131 LWSD Geneva AC Mains Replacement\dwg\2013-131\_C6.1-C6.3 Plan and Profile Geneva Lakeway.dwg, 2/17/2015 12:40:20 PM, PDF-XChange 22x34.pc3, TIDN

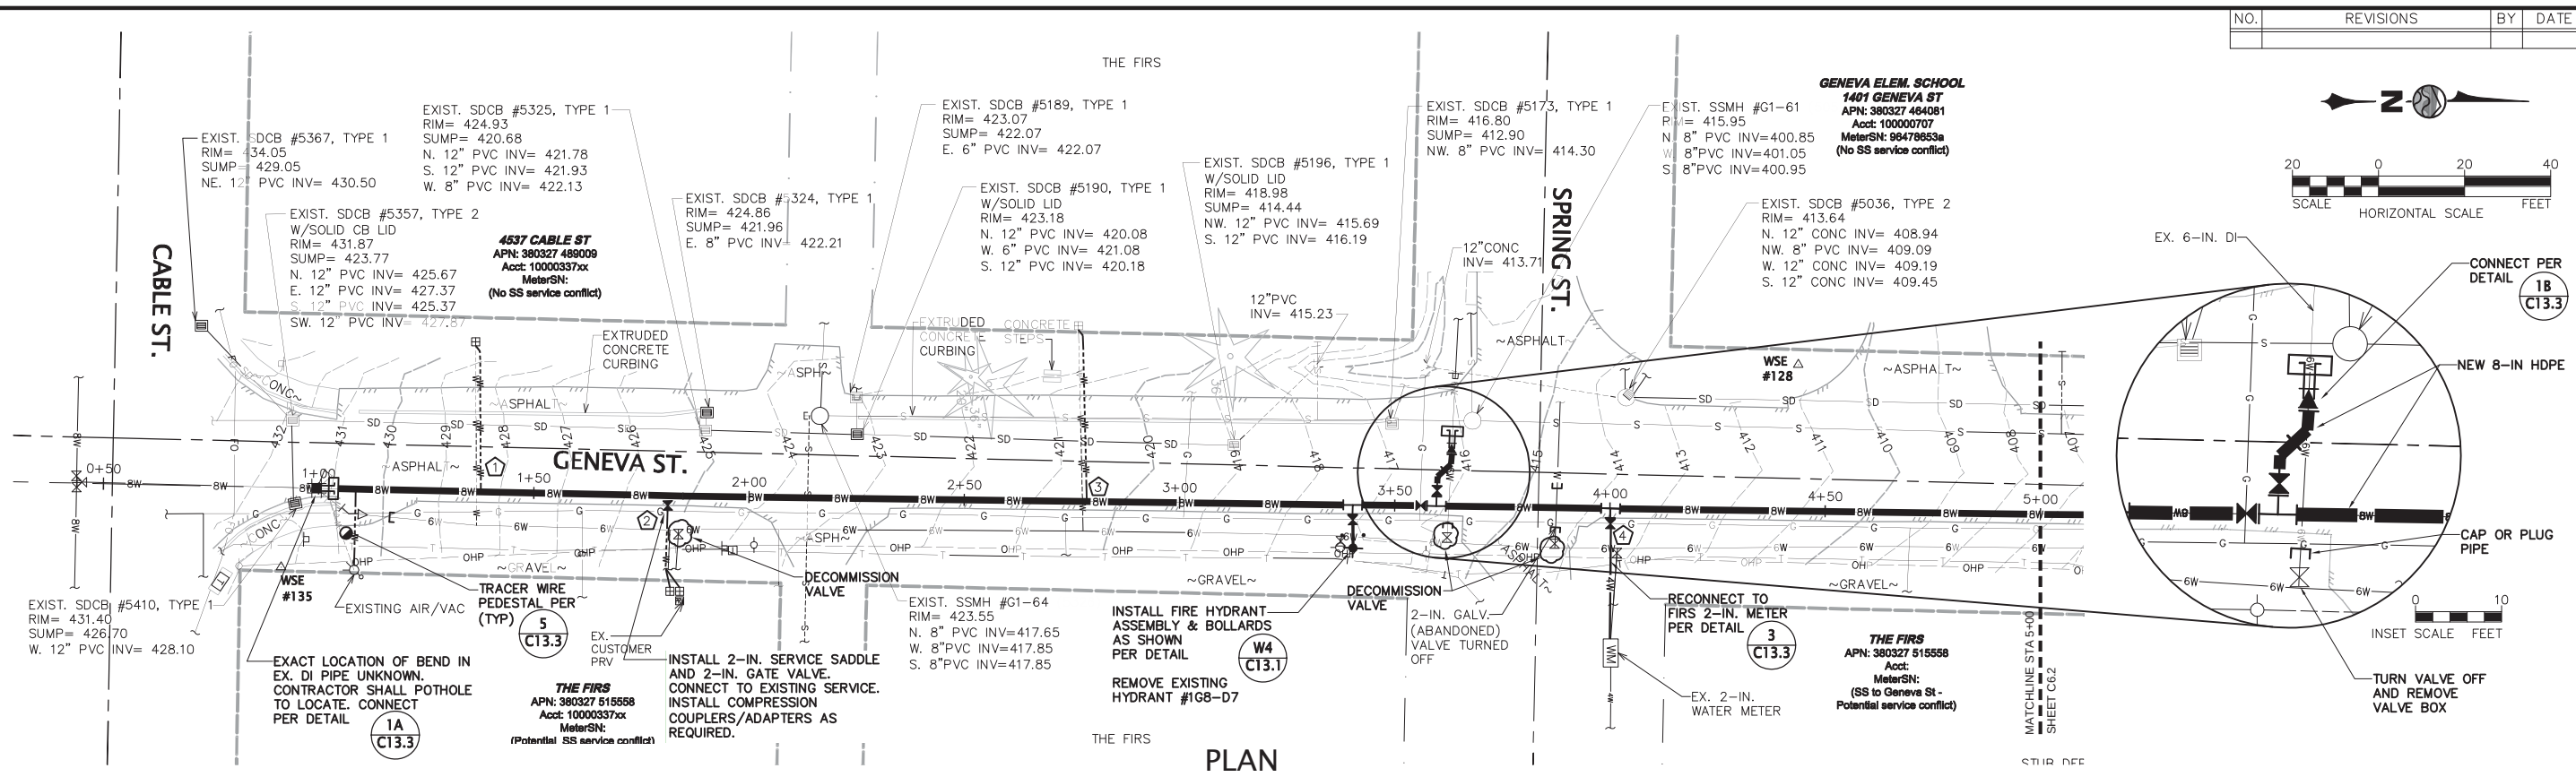

PLAN

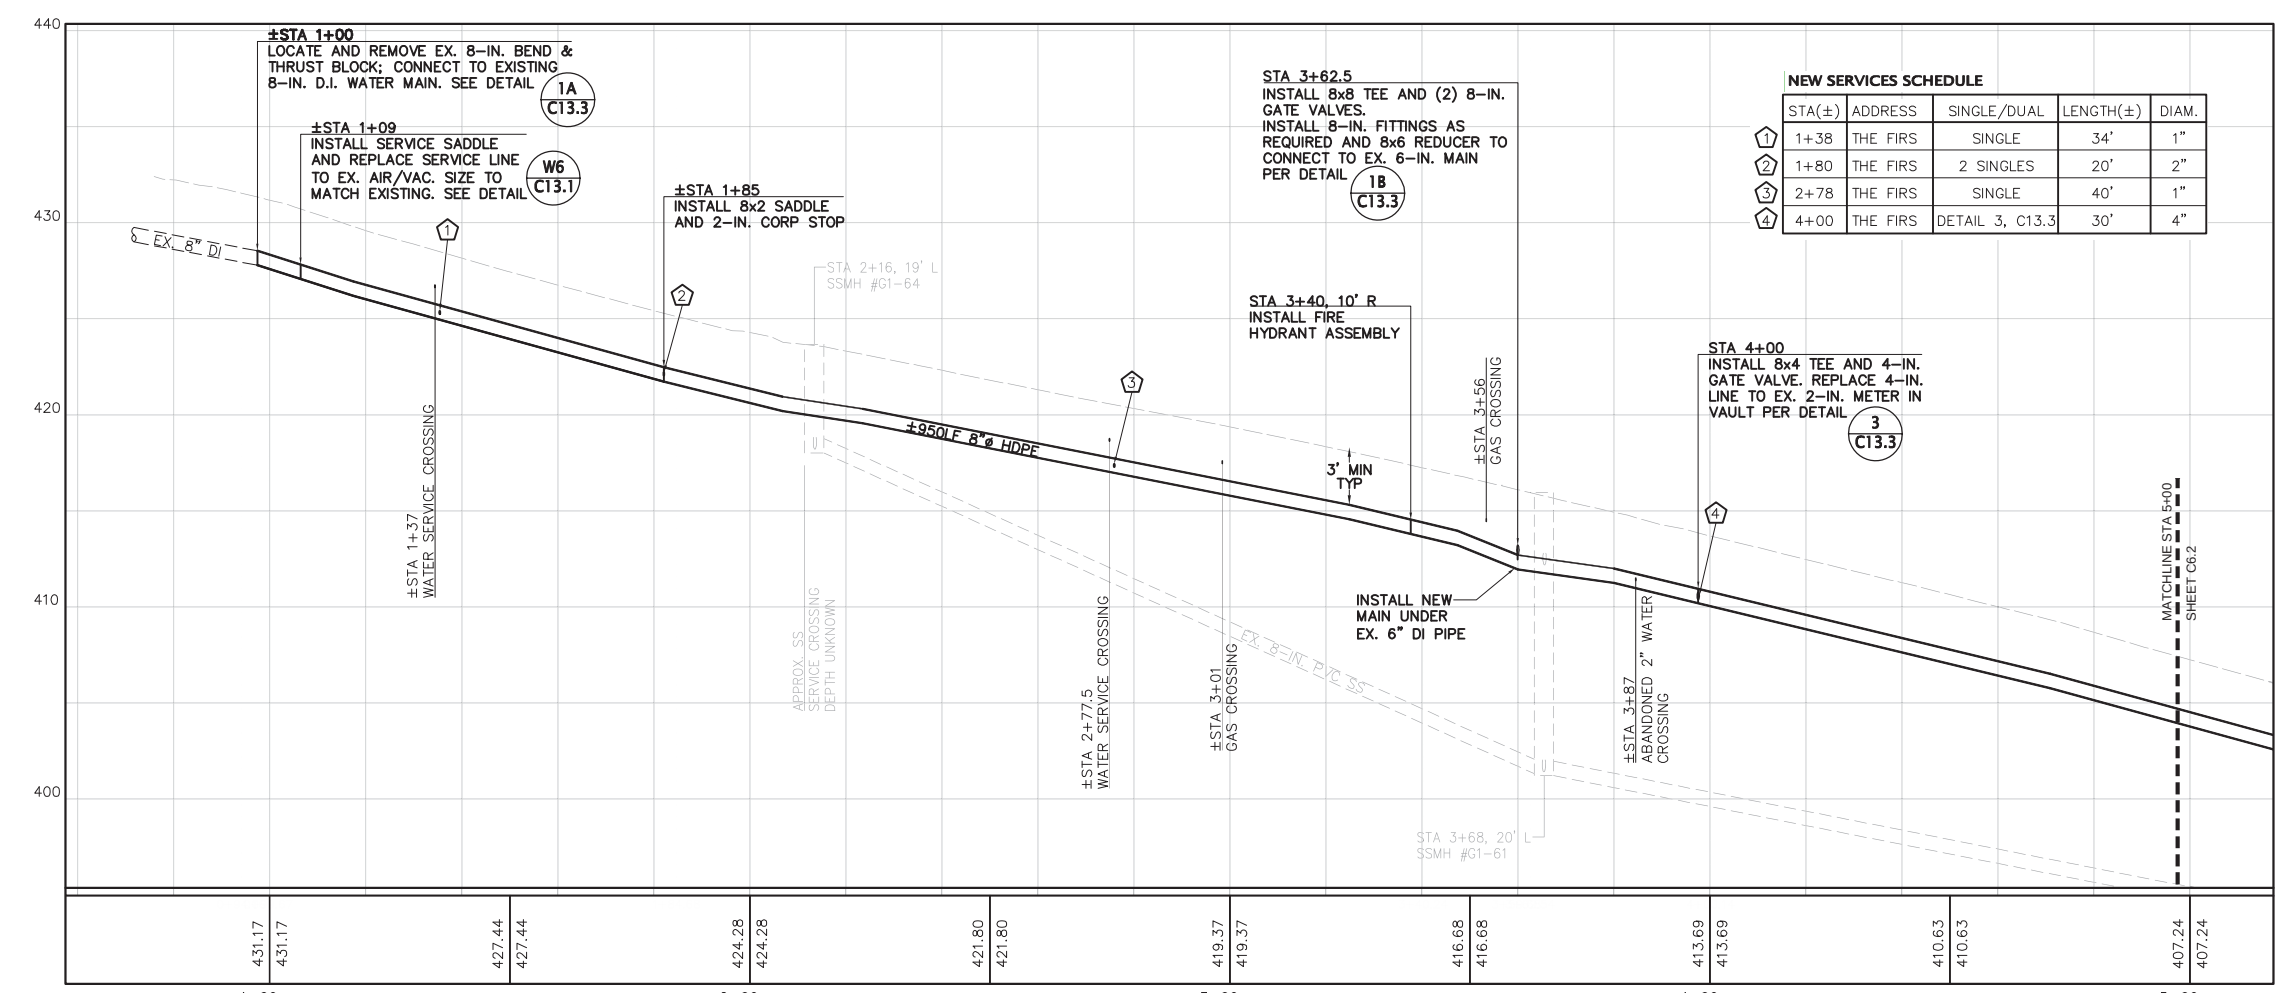

PROFILE - GENEVA STREET

CALL  
TWO BUSINESS DAYS  
BEFORE YOU DIG  
1-800-424-5555  
UTILITIES UNDERGROUND LOCATION CENTER

| NO. |  | REVISIONS |  | BY | DATE |
|-----|--|-----------|--|----|------|
|     |  |           |  |    |      |

SCALE  
HORIZONTAL SCALE  
FEET  
20 0 20 40

INSET SCALE  
FEET  
0 10

**Wilson**  
SURVEY/ENGINEERING

2/17/15


**LAKE WHATCOM WATER & SEWER DISTRICT**  
WASHINGTON  
GENEVA AC MAINS REPLACEMENT PROJECT  
PLAN & PROFILE - GENEVA ST./LAKEWAY DR. (E. OF GENEVA)  
STA 1+00 TO STA 5+00

DATE: FEBRUARY 4, 2015  
SCALE: AS SHOWN  
JOB NUMBER: 2013-131


SHEET: **C6.1** OF **37**

DESIGNED BY: MIM  
DRAWN BY: RDN  
CHECKED BY: DNC

WILSON ENGINEERING, LLC  
805 DUPONT STREET  
BELLINGHAM, WA 98225  
(360) 733-6100 • FAX (360) 647-9061  
www.wilsonengineering.com

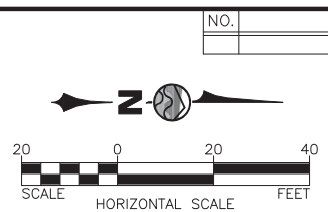

| NEW SERVICES SCHEDULE |        |          |             |           |       |
|-----------------------|--------|----------|-------------|-----------|-------|
|                       | STA(±) | ADDRESS  | SINGLE/DUAL | LENGTH(±) | DIAM. |
| 5                     | 7+93   | THE FIRS | SINGLE      | 28'       | 1"    |
| 6                     | 9+04   | THE FIRS | SINGLE      | 19'       | 1"    |
| 7                     | 9+76   | THE FIRS | SINGLE      | 14'       | 1"    |

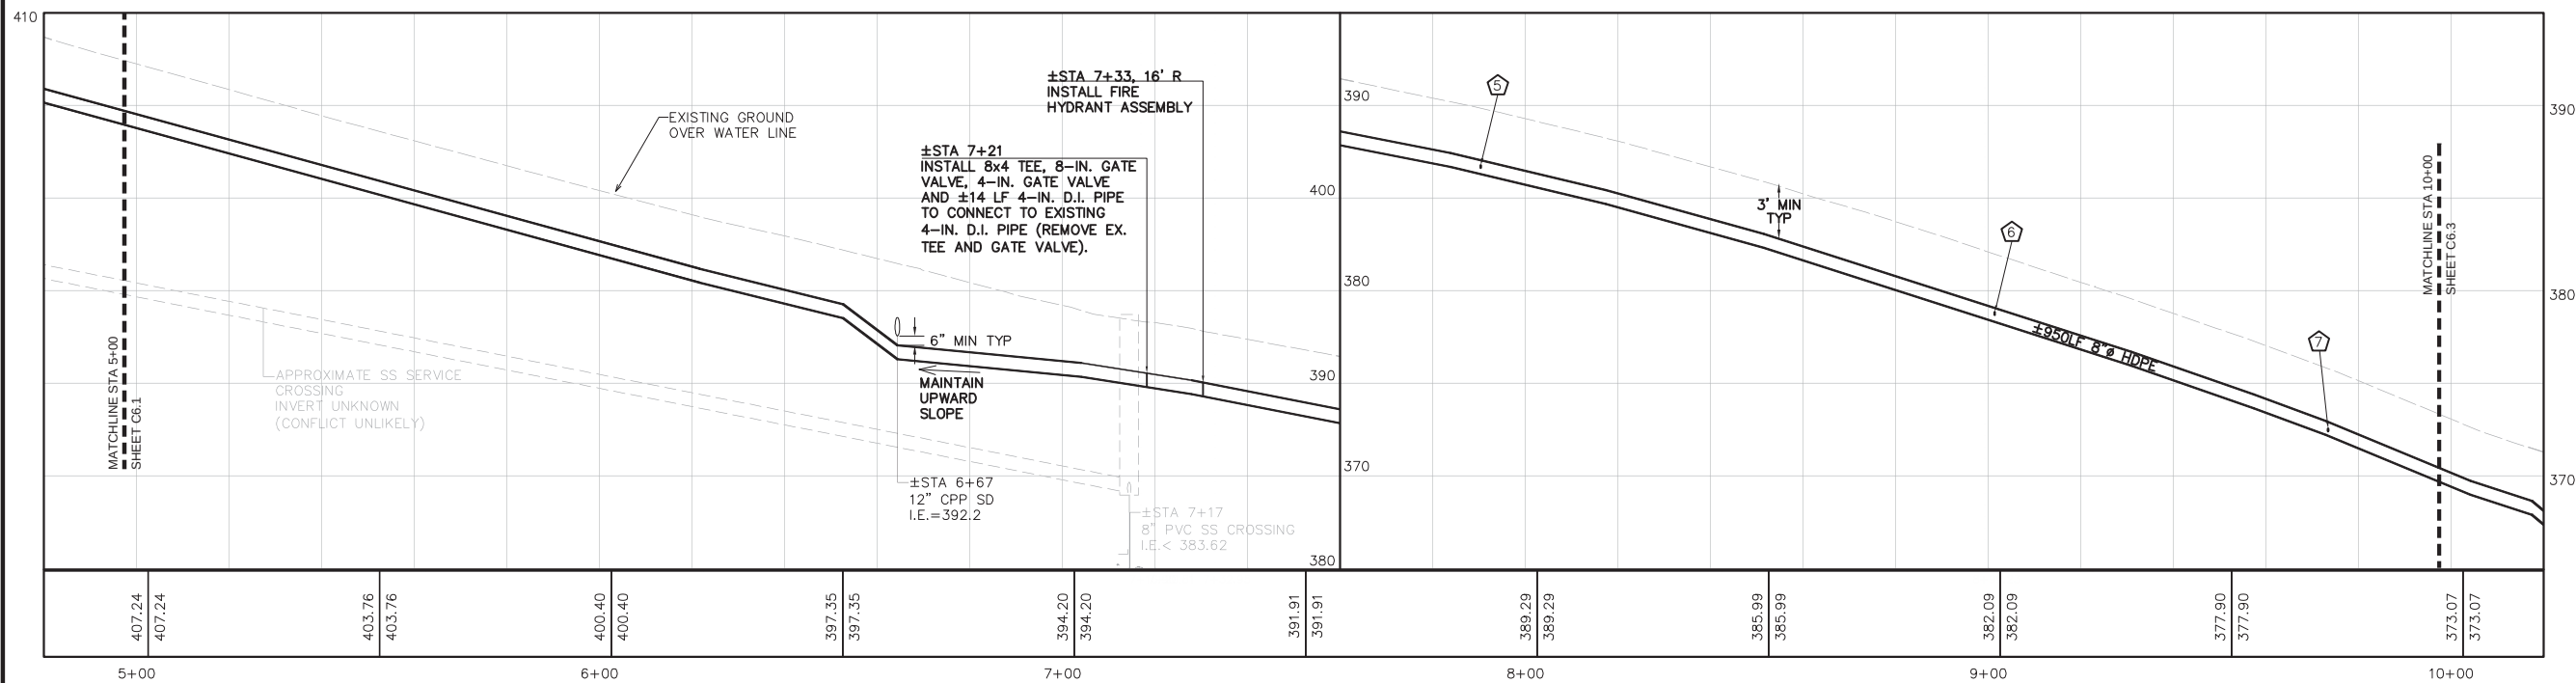

## PROFILE – GENEVA STREET

|                      |                          |                                                                                                                                                                                                                                    |  |
|----------------------|--------------------------|------------------------------------------------------------------------------------------------------------------------------------------------------------------------------------------------------------------------------------|--|
| SHEET<br><b>C6.2</b> | DATE<br>FEBRUARY 4, 2015 | <b>LAKE WHATCOM WATER &amp; SEWER DISTRICT</b><br><br>BELLINGHAM WASHINGTON<br><br><b>GENEVA AC MAINS REPLACEMENT PROJECT</b><br><br><b>PLAN &amp; PROFILE -GENEVA ST./LAKEWAY DR. (E. OF GENEVA)</b><br><br>STA 5+00 TO STA 10+00 |  |
|                      | SCALE<br>AS SHOWN        |                                                                                                                                                                                                                                    |  |
| OF<br><b>37</b>      | JOB NUMBER<br>2013-131   |                                                                                                                                                                                                                                    |  |

DESIGNED BY  
MMM

DRAWN BY  
RDN

CHECKED BY  
DNC



2/4/15


WILSON ENGINEERING, LLC  
805 DUPONT STREET  
BELLINGHAM, WA 98225  
(360) 733-6100 • FAX (360) 647-9061

www.wilsonengineering.com



**Wilson**  
**SURVEY/ENGINEERING**


W:\2013\2013-131 LWWSD Geneva AC Mains Replacement\dwg\2013-131 C6.1-C6.3 Plan and Profile Geneva Lakeway.dwg, 2/4/2015 11:16:24 AM, PDF-XChange 22x34.pc3, RDN

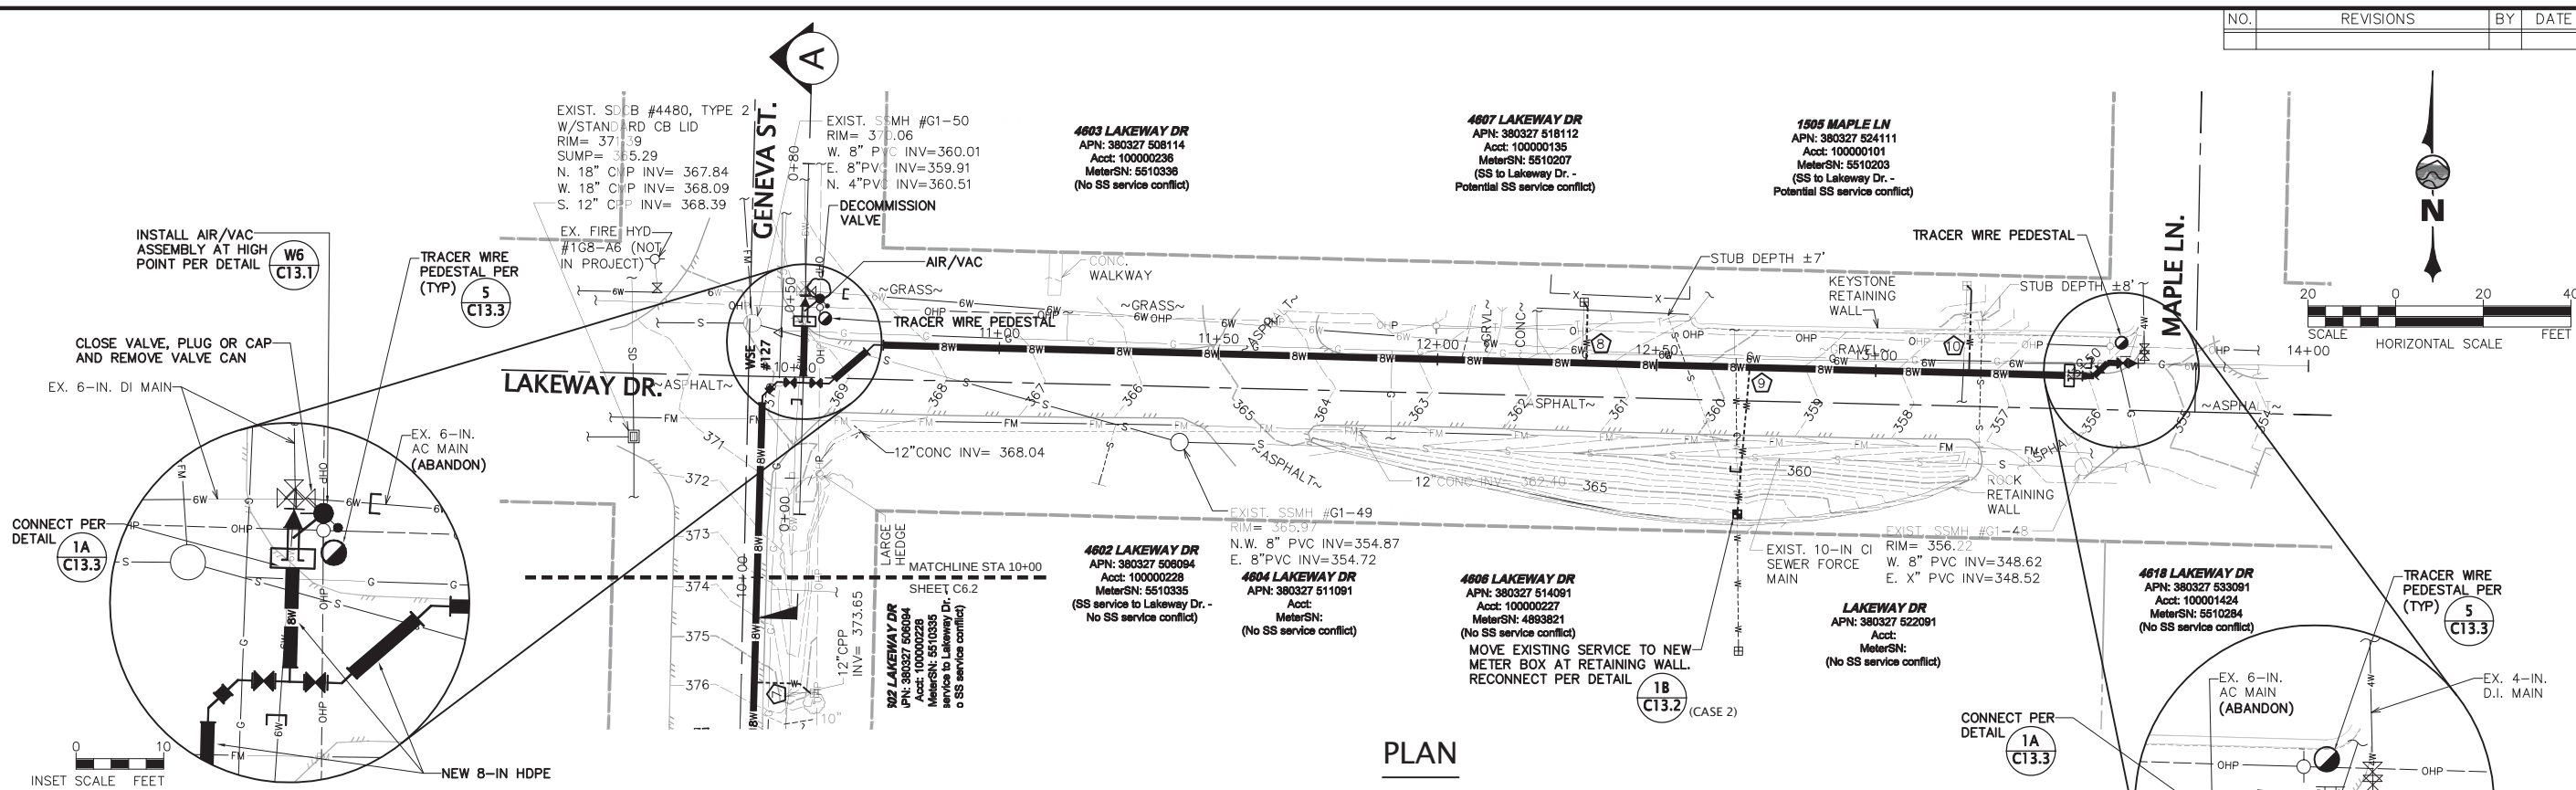


NEW SERVICES SCHEDULE

| STA(±) | ADDRESS              | SINGLE/DUAL | LENGTH(±) | DIAM. |
|--------|----------------------|-------------|-----------|-------|
| 12+34  | 4607 LAKEWAY DR.     | SINGLE      | 14'       | 1"    |
| 12+71  | 4606 LAKEWAY-THIERS* | SINGLE      | 33'       | 1"    |
| 13+21  | 1505 MAPLE LN.       | SINGLE      | 19'       | 1"    |

\*MOVE SERVICE TO NORTH SIDE OF RETAINING WALL AS SHOWN. RECONNECT PER DETAIL 1B (CASE 2) SHEET C13.2.

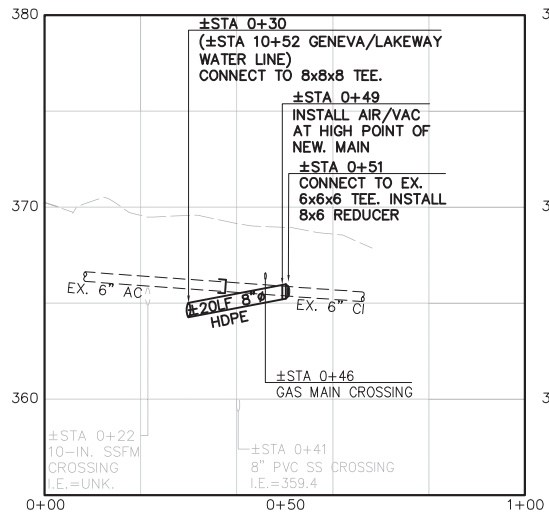

PROFILE A

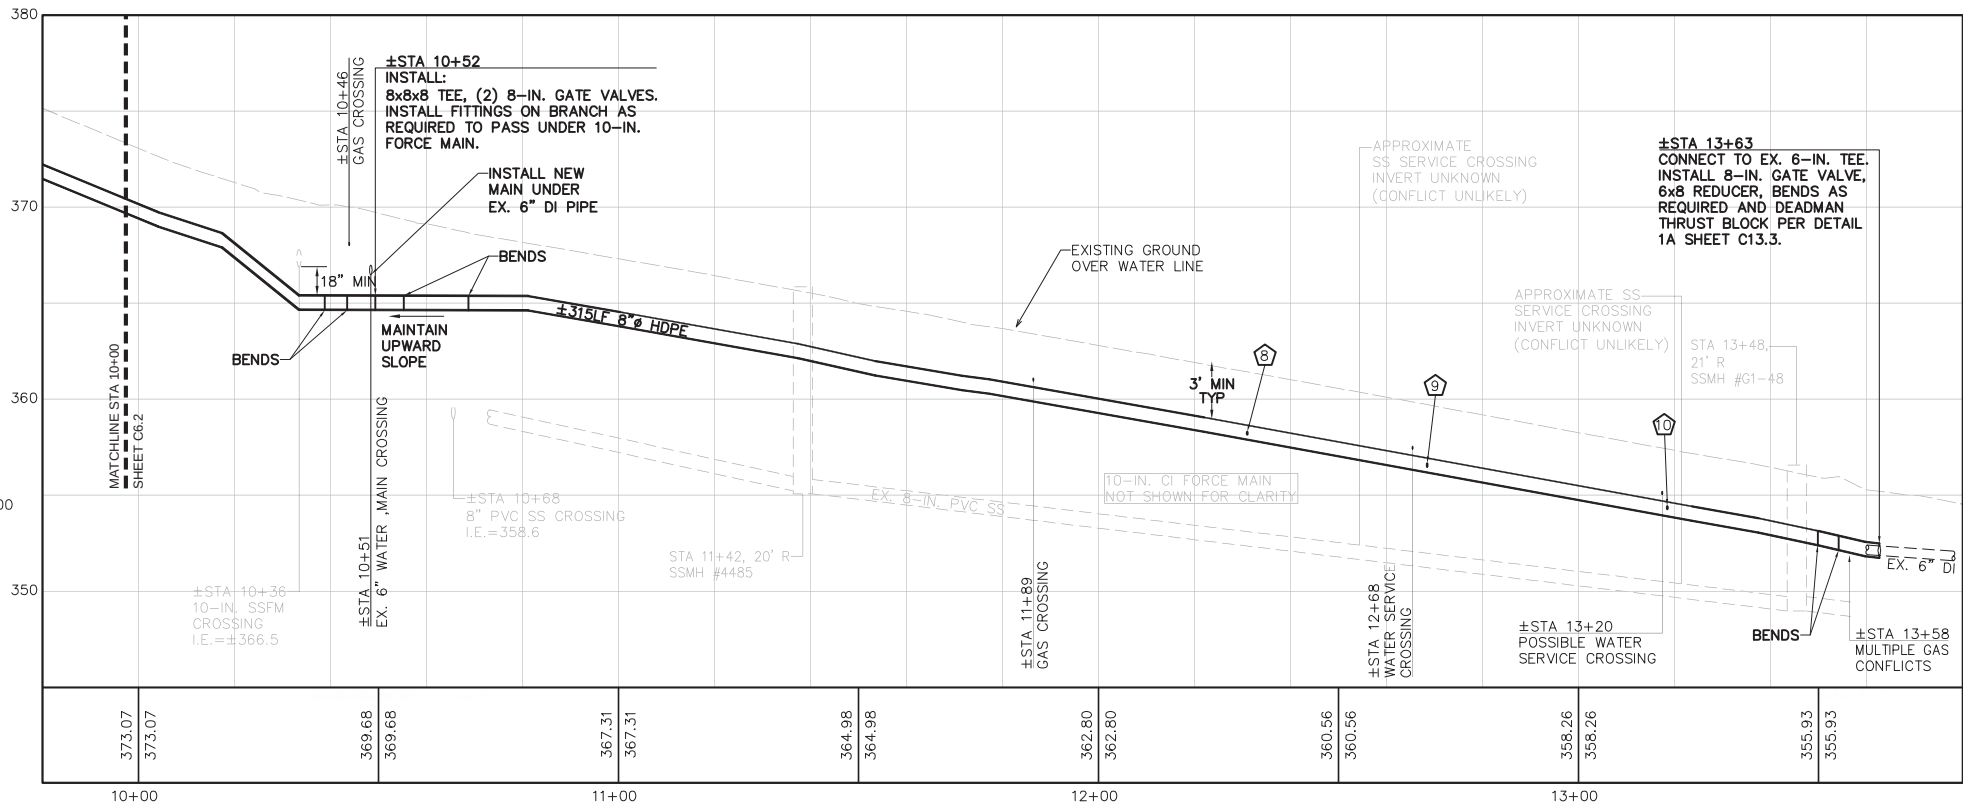

PROFILE - LAKEWAY DRIVE (EAST OF GENEVA STREET)

CALL  
TWO BUSINESS DAYS  
BEFORE YOU DIG  
1-800-424-5555  
UTILITIES UNDERGROUND LOCATION CENTER

|                                                                                                                                                                                                                                                                                                                                                            |  |           |  |       |      |
|------------------------------------------------------------------------------------------------------------------------------------------------------------------------------------------------------------------------------------------------------------------------------------------------------------------------------------------------------------|--|-----------|--|-------|------|
| NO.                                                                                                                                                                                                                                                                                                                                                        |  | REVISIONS |  | BY    | DATE |
| <div>WILSON ENGINEERING, LLC<br/>805 DUPONT STREET<br/>BELLINGHAM, WA 98225<br/>(360) 733-6100 • FAX (360) 647-9061<br/>www.wilsonengineering.com</div> <div><b>Wilson</b><br/>SURVEY/ENGINEERING</div> <div><p>DESIGNED BY: MIM<br/>DRAWN BY: RDN<br/>CHECKED BY: DNC</p><p>DATE: FEBRUARY 4, 2015<br/>SCALE: AS SHOWN<br/>JOB NUMBER: 2013-131</p></div> |  |           |  |       |      |
| LAKE WHATCOM WATER & SEWER DISTRICT<br>WASHINGTON<br>GENEVA AC MAINS REPLACEMENT PROJECT<br>PLAN & PROFILE - GENEVA ST./LAKEWAY DR. (E. OF GENEVA)<br>STA 10+00 TO STA 13+55                                                                                                                                                                               |  |           |  |       |      |
| SHEET                                                                                                                                                                                                                                                                                                                                                      |  | C6.3      |  | OF 37 |      |