
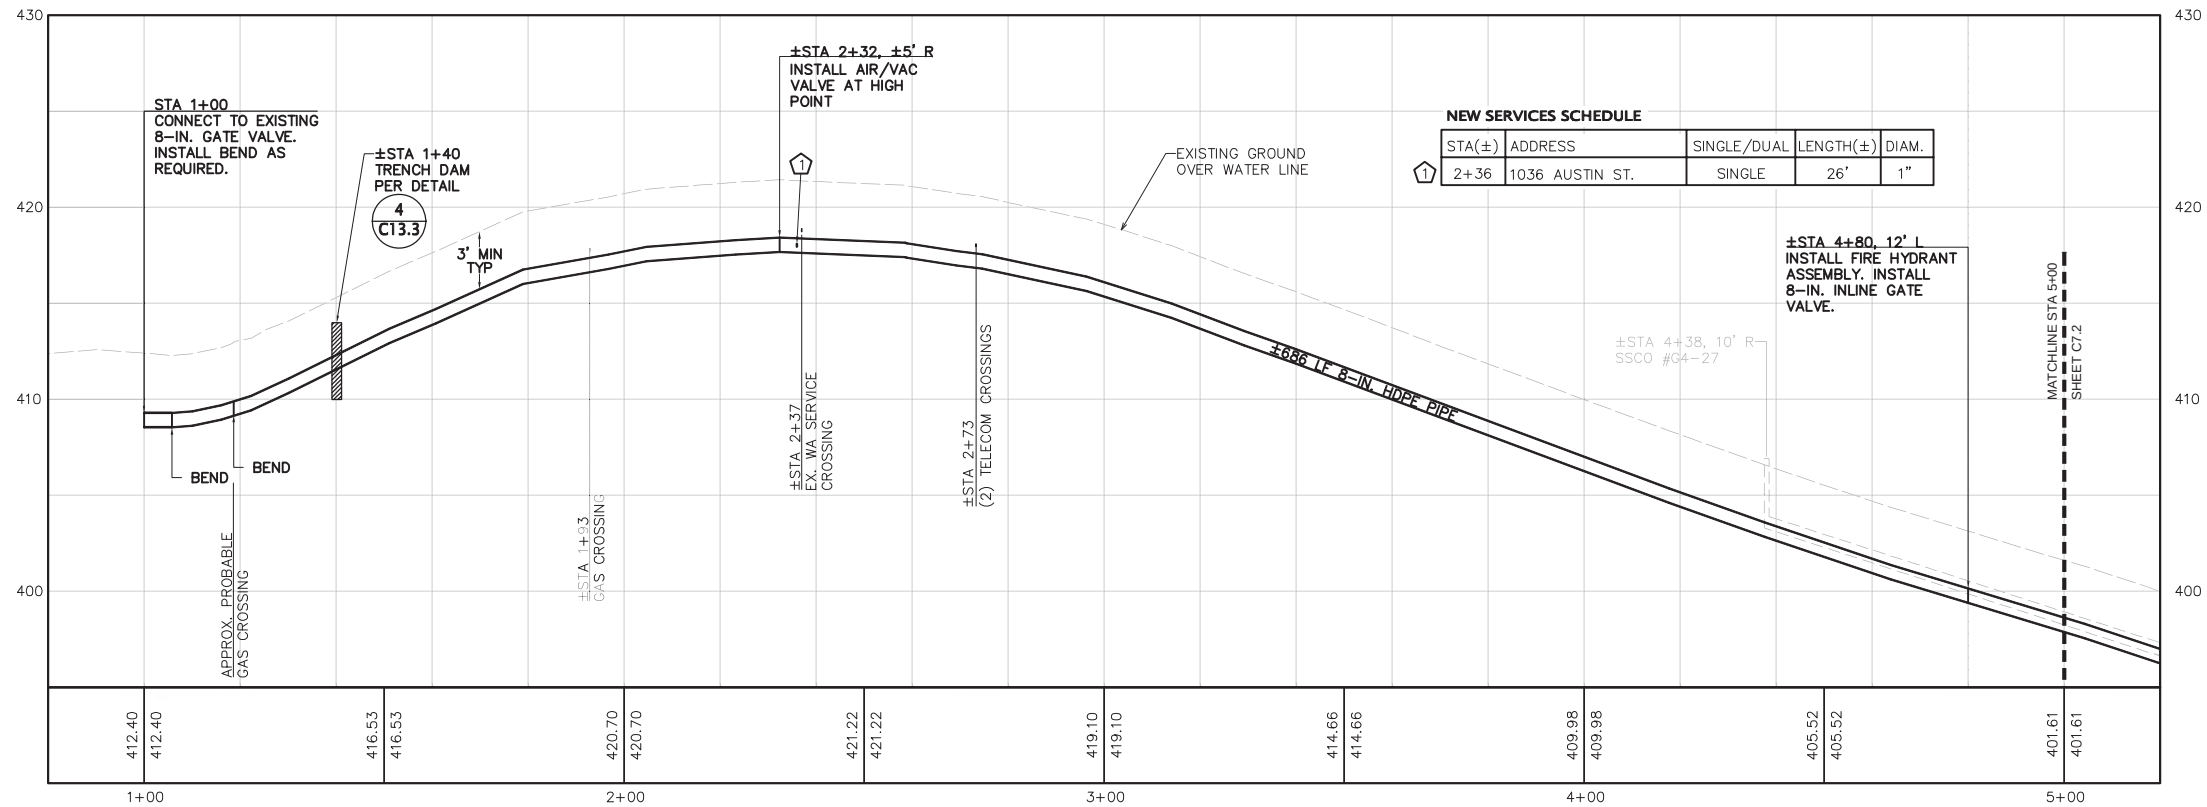


W:\2013\2013-131 LWWSD Geneva AC Mains Replacement\dwg\2013-131-131 C7.1-C7.2 Plan and Profile for Fir Tree Ln.dwg, 2/4/2015 11:17:39 AM, PDF-XChange 22/24.pc3, RDN

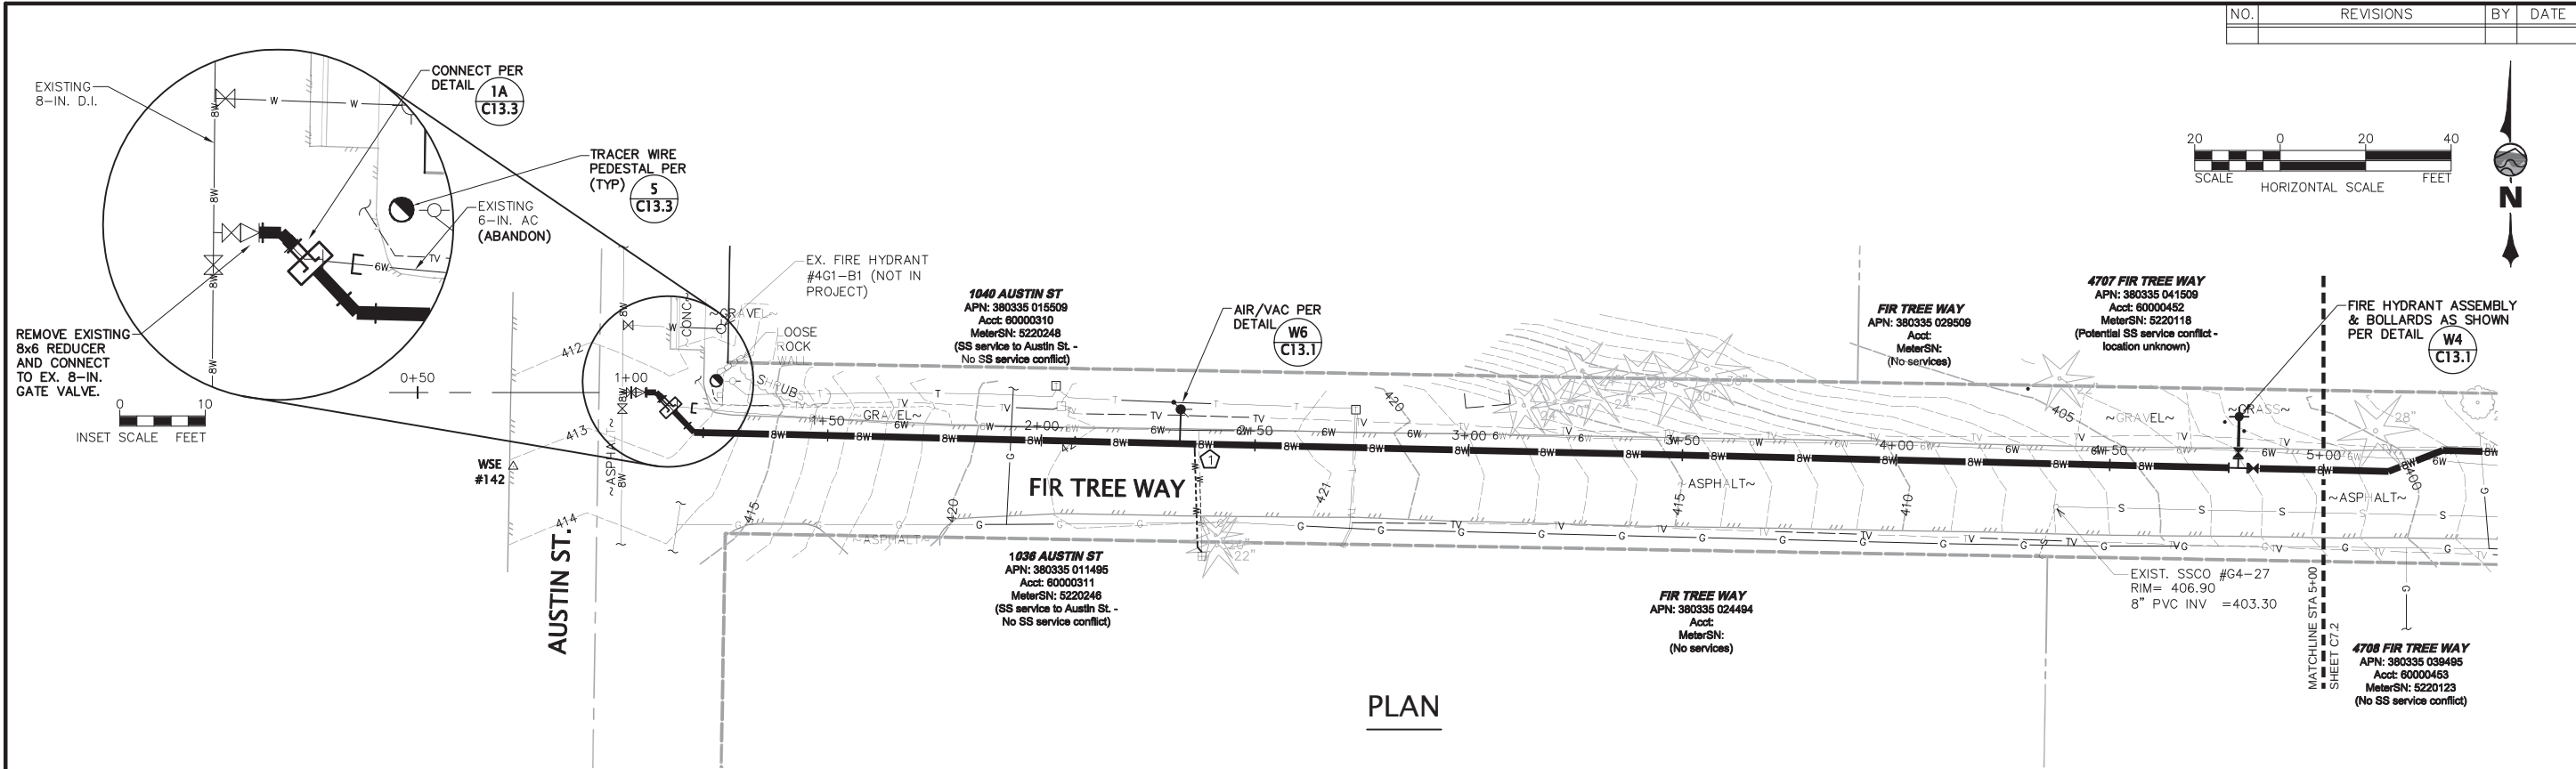

CALL
TWO BUSINESS DAYS
BEFORE YOU DIG
1-800-424-5555
UTILITIES UNDERGROUND LOCATION CENTER

WILSON ENGINEERING, LLC
805 DUPONT STREET
BELLINGHAM, WA 98225
(360) 733-6100 • FAX (360) 647-9061
www.wilsonengineering.com

Wilson
SURVEY/ENGINEERING

MELANIE M. MARKHAM
STATE OF WASHINGTON
35766
REGISTERED PROFESSIONAL ENGINEER
2/4/15

DESIGNED BY MIM
DRAWN BY RDN
CHECKED BY DNC

LAKE WHATCOM WATER & SEWER DISTRICT
WASHINGTON
GENEVA AC MAINS REPLACEMENT PROJECT
PLAN & PROFILE - FIR TREE WAY
STA 1+00 TO STA 5+00

DATE
FEBRUARY 4, 2015
SCALE
AS SHOWN
JOB NUMBER
2013-131

SHEET
C7.1
OF
37

W:\2013\2013-131 LWW&D Geneva AC Mains Replacement\dwg\2013-131 C7.1-C7.2 Plan and Profile for Tree Ln.dwg, 2/4/2015 11:18:11 AM, PDF-XChange 22/24.pc3, RDN


4707 FIR TREE WAY
APN: 380335 041509
Acct: 80000452
MeterSN: 5220118
(Potential SS service conflict - location unknown)

4708 FIR TREE WAY
APN: 380335 039495
Acct: 80000453
MeterSN: 5220123
(No SS service conflict)


4716 FIR TREE WAY
APN: 380335 054495
Acct: 80000581
MeterSN: 5220120
(No SS service conflict)

4715 FIR TREE WAY
APN: 380335 054509
Acct: 60000829
MeterSN: 5220122
(SS service conflict)

4721 FIR TREE WAY
APN: 380335 070501
Acct: 60000829
MeterSN: 5220122
(SS service conflict)

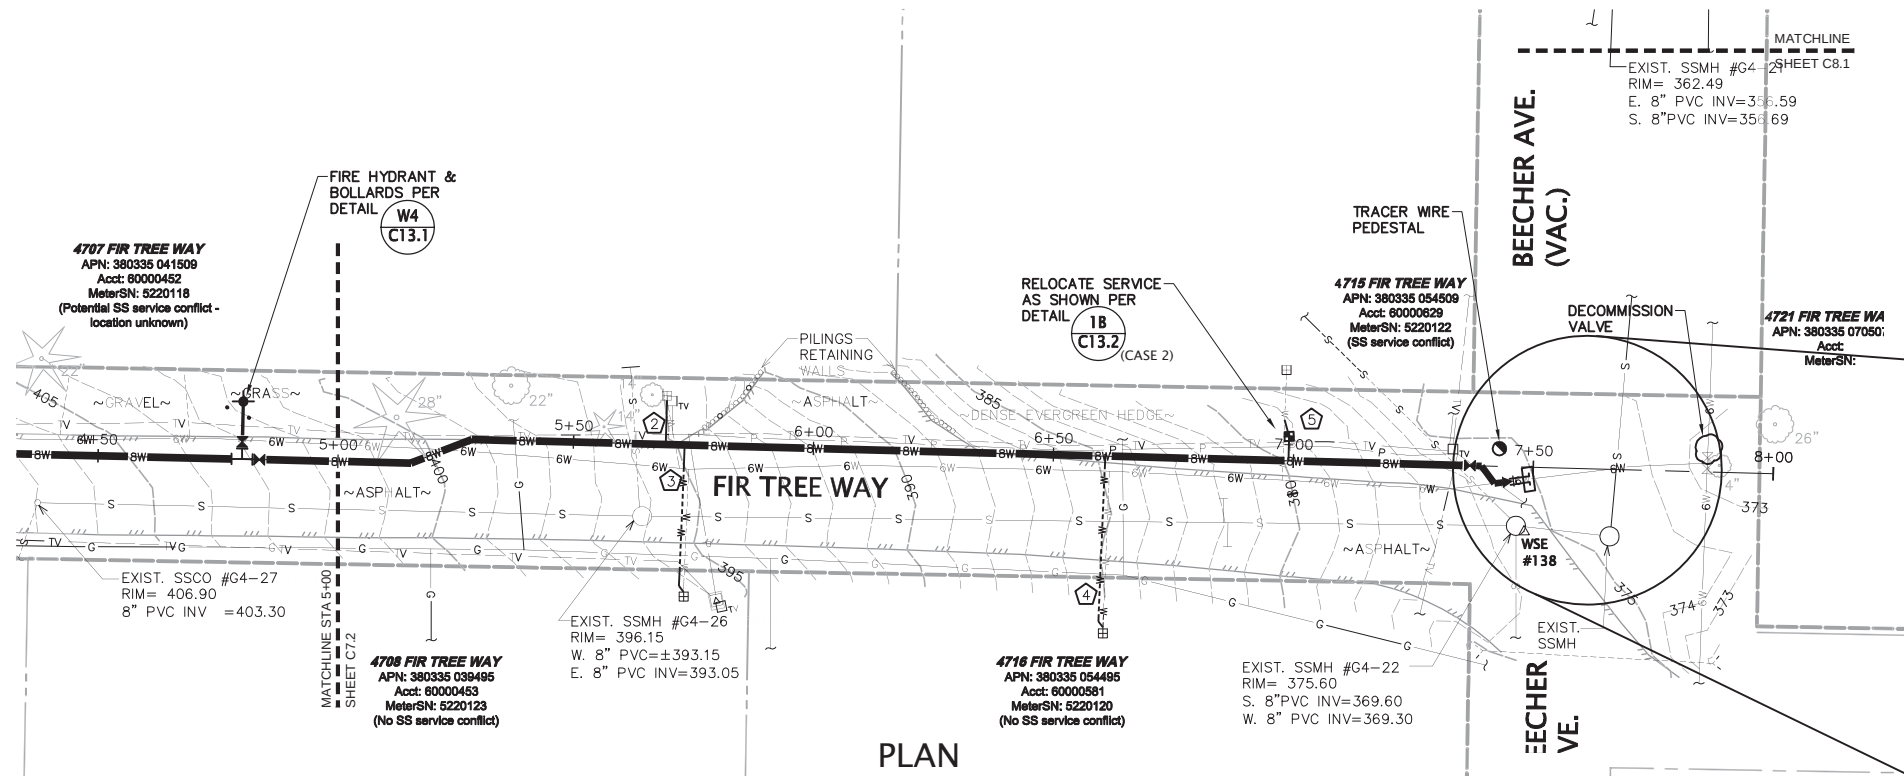

PLAN

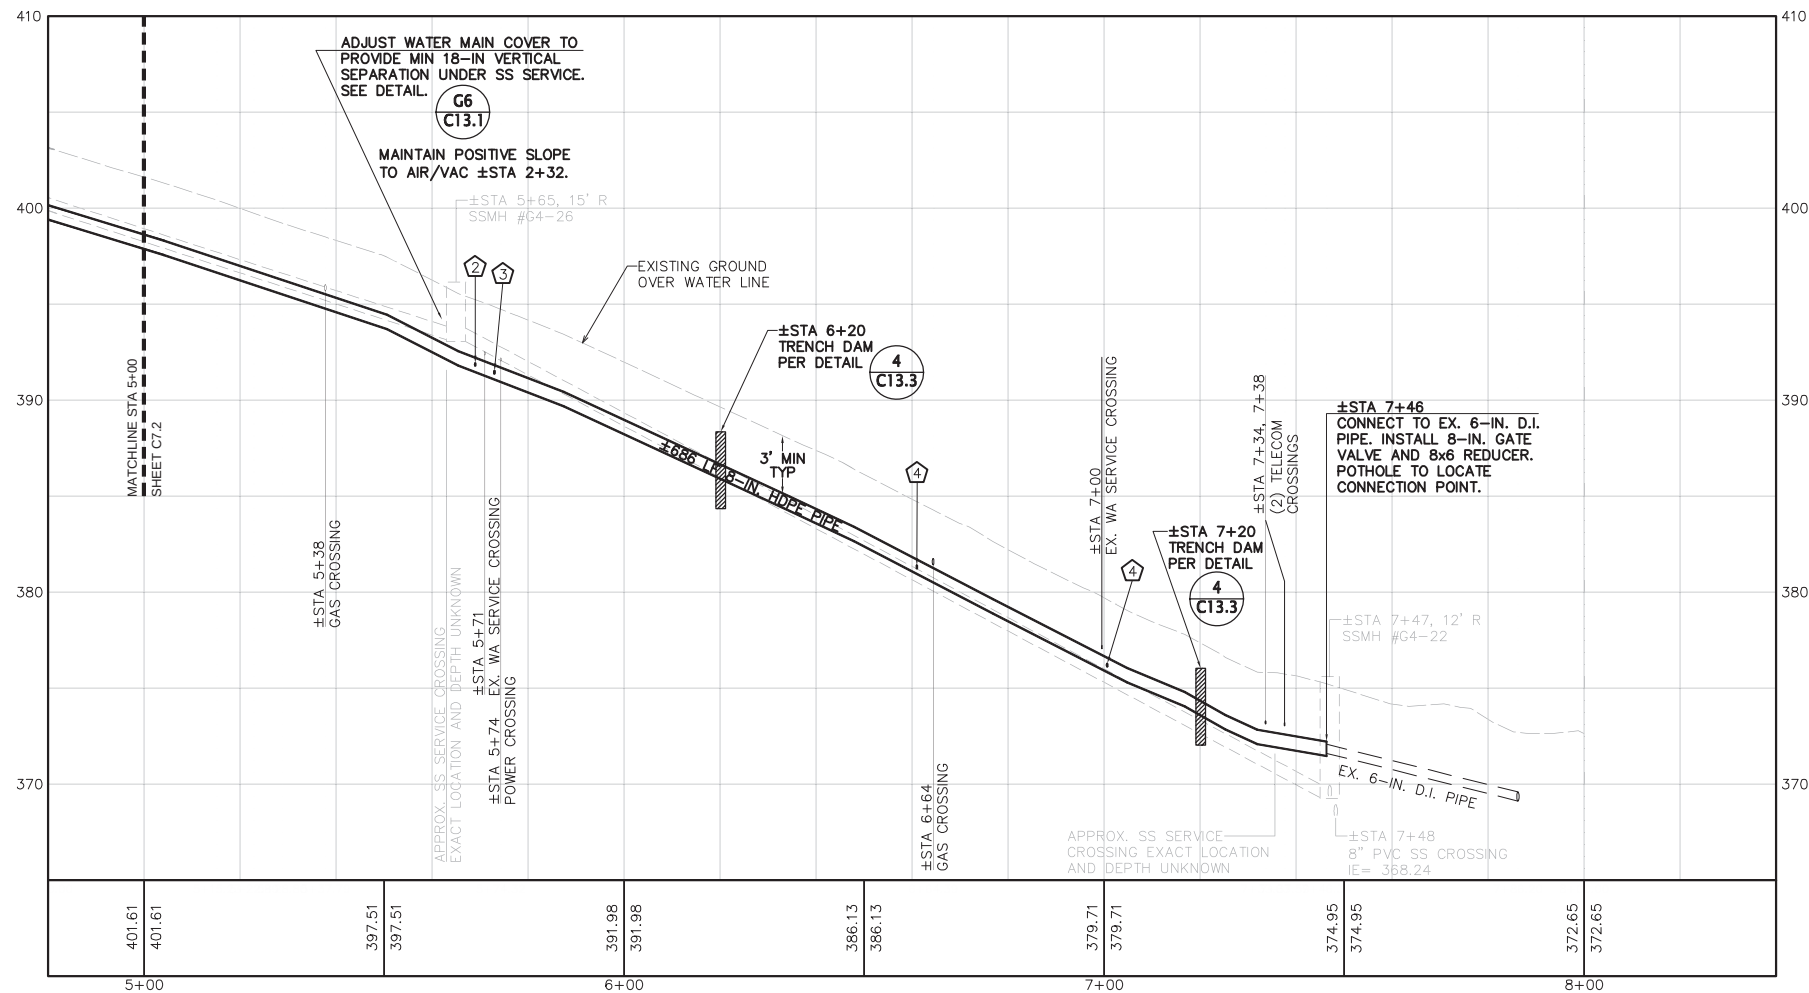

PROFILE - FIR TREE WAY

NEW SERVICES SCHEDULE

STA(±)	ADDRESS	SINGLE/DUAL	LENGTH(±)	DIAM.
② 5+69	4707 FIR TREE WAY	SINGLE	9'	1"
③ 5+73	4708 FIR TREE WAY	SINGLE	31'	1"
④ 6+61	4717 FIR TREE WAY	SINGLE	36'	1"
⑤ 7+00	4715 FIR TREE WAY*	SINGLE	12'	1"

*MOVE SERVICE TO NEW LOCATION AS SHOWN AND CONNECT PER DETAIL 1B (CASE 2) SHEET C13.2.

CALL
TWO BUSINESS DAYS
BEFORE YOU DIG
1-800-424-5555
UTILITIES UNDERGROUND LOCATION CENTER

WILSON ENGINEERING, LLC
805 DUPONT STREET
BELLINGHAM, WA 98225
(360) 733-6100 • FAX (360) 647-9061
www.wilsonengineering.com



DESIGNED BY MIM
DRAWN BY RDN
CHECKED BY DNC

LAKE WHATCOM WATER & SEWER DISTRICT

WASHINGTON

GENEVA AC MAINS REPLACEMENT PROJECT

PLAN & PROFILE - FIR TREE WAY

STA 5+00 TO STA 7+90

DATE
FEBRUARY 4, 2015

SCALE
AS SHOWN

JOB NUMBER
2013-131

SHEET
C7.2

OF

37